


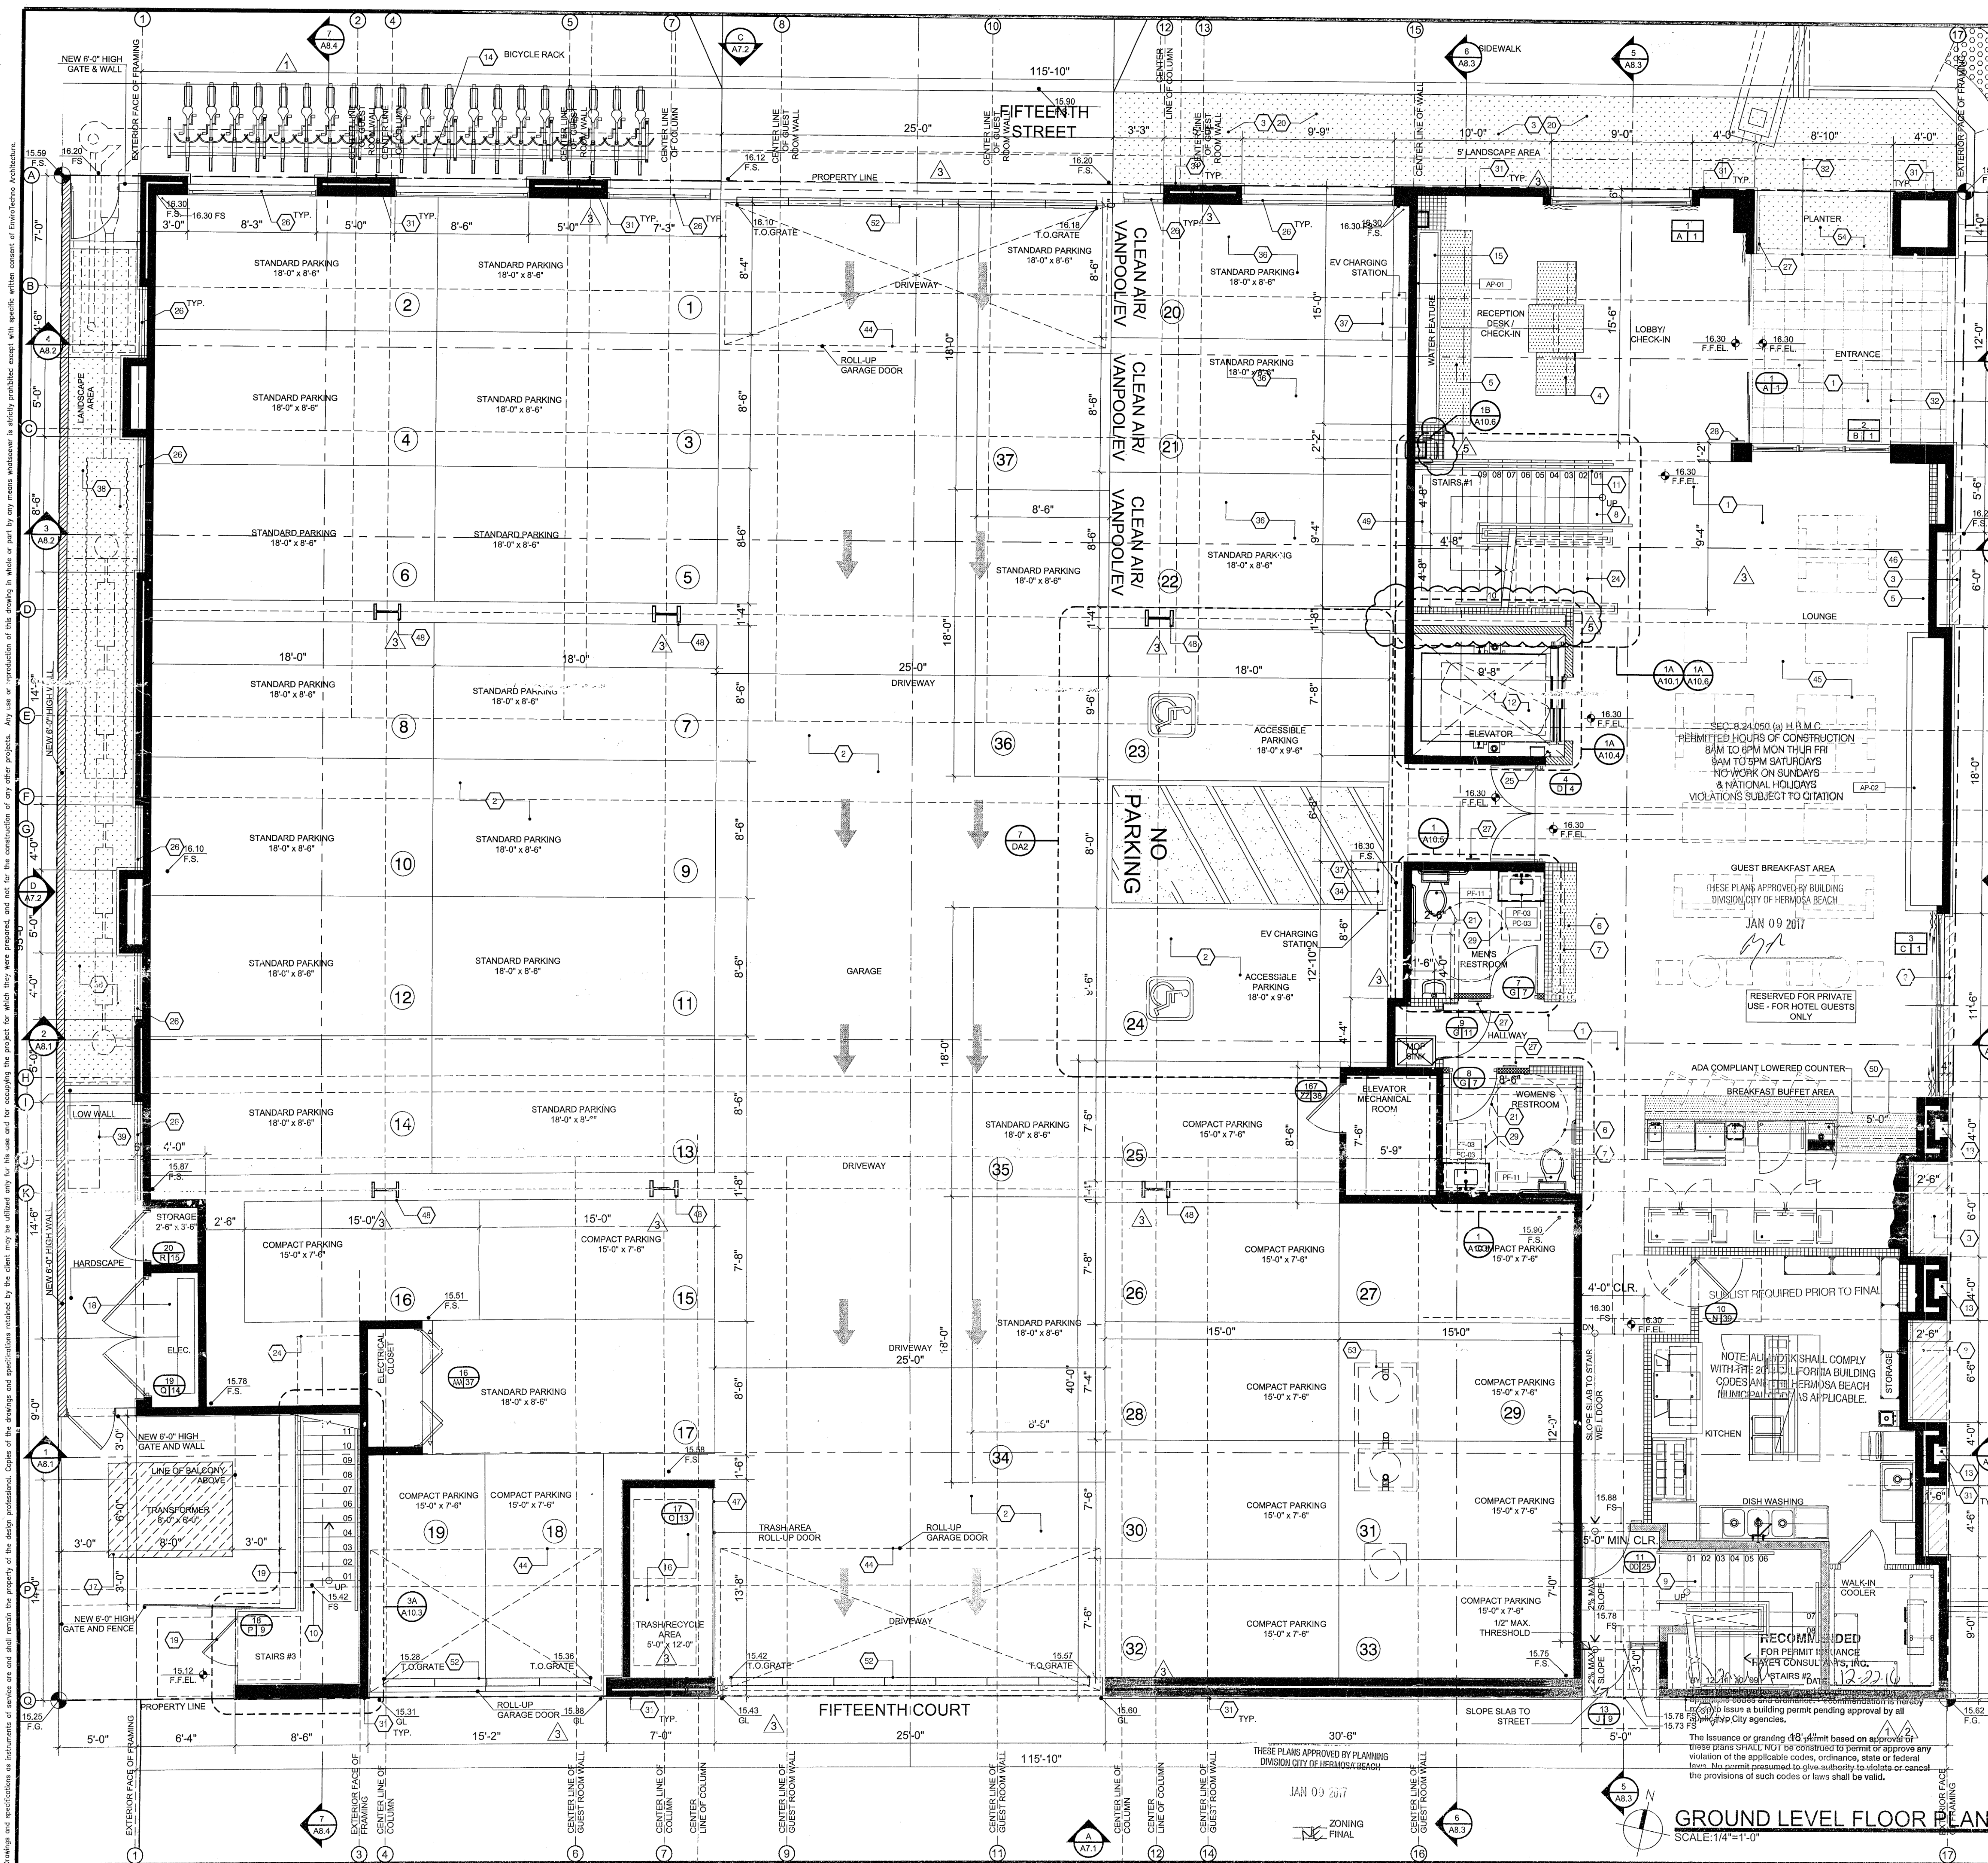

GENERAL LEGEND

24# WOOD STUDS @ 16" O.C. - U.N.O. - 1-LHR RATED WALL WITH 58" TYPE 'C' GYP BOARD AT INTERIOR SIDE. (SEE FINISH SCHEDULE AND INTERIOR ELEVATIONS FOR ADDITIONAL FINISHES). USE 7/8" CEMENT PLASTER W/ SMOOTH AND ANTI-GRAFFITI FINISHES. PROVIDE EXTERIOR SURFACING INCLUDING ALL FOR INTERIOR GARAGE WALLS. SEE ELEVATIONS FOR EXTERIOR FINISHES. PROVIDE SOUND ATTENUATION IN 150-180 INBULATION (SEE STRUCTURAL DRAWINGS FOR ADDITIONAL INFORMATION). PROVIDE SOUND FURNISHING OCCURS - SEE DETAILS 11A107, 31A107, 41A107, 51A107, 61A107.

24# WOOD STUDS @ 16" O.C. STAGGERED ON 24# PLATES TOP & BOTTOM USING 3/4" SKILL PLATES WHERE NECESSARY. PROVIDE STRUCTURAL - U.N.O. - 1-LHR RATED WALL WITH 58" TYPE 'C' GYP BOARD ON EACH SIDE - SEE DETAIL 91A107, 11A107.

24# WOOD STUDS @ 16" O.C. - U.N.O. - 1-LHR RATED WALL WITH 58" TYPE 'C' GYP BOARD ON EACH SIDE - SEE DETAIL STRUCTURAL - U.N.O.

24# WOOD STUDS @ 16" O.C. STAGGERED ON 24# PLATES TOP & BOTTOM USING 3/4" SKILL PLATES WHERE NECESSARY. PROVIDE STRUCTURAL - U.N.O. - 1-LHR RATED WALL WITH 58" TYPE 'C' GYP BOARD ON EACH SIDE - SEE DETAIL 91A107.

24# WOOD STUDS @ 16" O.C. STAGGERED ON 24# PLATES TOP & BOTTOM USING 3/4" SKILL PLATES WHERE NECESSARY. PROVIDE STRUCTURAL - U.N.O. - 1-LHR RATED WALL WITH 58" TYPE 'C' GYP BOARD ON EACH SIDE (USE 24# WOOD STUDS FOR PLUMBING AND ELECTRICAL PENETRATIONS). PROVIDE CRITICAL PARKING 'TEAM' LOCATION AT GARAGE SHAFT - SEE DETAIL 71A107.

24# WOOD STUDS @ 16" O.C. STAGGERED ON 24# PLATES TOP & BOTTOM USING 3/4" SKILL PLATES WHERE NECESSARY. PROVIDE STRUCTURAL - U.N.O. - 1-LHR RATED WALL WITH 58" TYPE 'C' GYP BOARD ON EACH SIDE (USE 24# WOOD STUDS FOR PLUMBING AND ELECTRICAL PENETRATIONS). PROVIDE CRITICAL PARKING CLEARANCES - CONTRACTOR TO ENSURE CRITICAL CLEARANCES PRIOR TO CONSTRUCTION. PROVIDE CRITICAL PARKING CLEARANCES - CONTRACTOR TO ENSURE CRITICAL CLEARANCES PRIOR TO CONSTRUCTION. MANUFACTURED BY SHIELD INDUSTRIES FIREGUARD E-84 - SEE DETAIL 21A107.

MILLYCROW - REFER TO INTERIOR DESIGN DRAWINGS FOR DESIGN AND DETAILING.

LANDSCAPE AREA - SEE LANDSCAPE PLANS

ACCESSIBLE PARKING/GUESTROOM - SEE SHEETS D4 & D2

PROVIDE COMMUNICATION EQUIPMENT FOR THE HEARING IMPAIRED PER CBC TABLE 115-203 & 115-204.1

KEY NOTES

1	TERRAZZO FLOOR OR FLOOR TILE - SEE INTERIOR DESIGN DRAWINGS
2	CONCRETE SLAB - (VERIFY FINISH). ALL EXPOSED GARAGE WALLS TO BE 7/8" SMOOTH GEMENT PLASTER - U.N.O.
3	LANDSCAPE/PLANTING AREA - SEE LANDSCAPE PLANS
4	RECEPTION DESK/CHECK-IN COUNTER - REFER TO INTERIOR DESIGN DRAWINGS
5	BASE CABINET WITH STONE TOP - REFER TO INTERIOR DESIGN DRAWINGS
6	BASE CABINET WITH STONE TOP AND 6" TILE BACKSPLASH - REFER TO INTERIOR DESIGN DRAWINGS
7	UPPER CABINET - REFER TO INTERIOR DESIGN DRAWINGS
8	INTERIOR ENTRY STAIRS - REFER TO INTERIOR DESIGN DRAWINGS
9	INTERIOR EGRESS STAIRS - REFER TO INTERIOR DESIGN DRAWINGS
10	EXTERIOR EGRESS STAIRS - REFER TO INTERIOR DESIGN DRAWINGS
11	GUARDRAIL/HANDRAIL, MIN. 42" HIGH
12	ELEVATOR - TO BE ACCESSIBLE TO DISABLED PERSONS AND MEET THE STRETCHER REQUIREMENTS PER CBC SECTION 3002.4 (SPECS. TO FOLLOW). VERIFY REF. CLEARANCES W/ ELEVATOR MFG. W/ 20 MINUTE FIRE RATED DOORS SEE DETAILS 1/A0.1 AND 1/A0.8
13	SHIELDED EXTERIOR LIGHTING - (SPECS. TO FOLLOW)
14	BICYCLE RACK - (SPECS. TO FOLLOW) PER CBC S.106.4.1
15	WATER FEATURE - REFER TO INTERIOR DRAWINGS FOR SPECS.
16	TRASH/RECYCLE CONTAINER AREA
17	TRANSFORMER/TRANSFORMER PAD - SEE EDOISON/ELECTRICAL/CIVIL DRAWINGS
18	ELECTRICAL PANEL - SEE ELECTRICAL DRAWINGS
19	INTERIOR STAIRS FENCE AND GATE - SEE DETAIL SIM.
20	PROVIDE PATIO DRAIN, CONNECT TO LANDSCAPE DRAINAGE SYSTEM (REFER TO CIVIL DRAWINGS)
21	60" DIA. REQUIRED A.D.A. CLEARANCE
24	STAIRS ABOVE
25	PITCH LIGHTS AND SWITCH, CONVENIENCE OUTLETS WITH GFCI PROTECTION PER NEC, PLT ADDLER PER CAR (ACCORDING TO CODE) NOTE: MUST BE CLEAR OF ALL VEVATOR EQUIPMENT
26	WIRE MESH PANELS - PROVIDE SHOP DRAWINGS FOR ARCHITECTS REVIEW AND APPROVAL
27	AFFIX THE INTERNATIONAL ACCESSIBILITY SYMBOL AT ALL ACCESSIBLE ENTRANCES PER CBC SECTION 11B-25.4.11B-216.6. THE SIGN SHALL COMPLY WITH CWC SECTION 11B-703.7. THE SIGN SHALL BE LOCATED ADJACENT TO THE LATCH SIDE OF THE SINGLE DOOR OR RIG SIDE OF THE DOUBLE DOORS 60" AFF FOR CBC SECTION 11B-703.4.1. SEE DETAIL 1/D02 - VEHICLY LOCATION/DESIGN WITH ARCHITECT ON SITE
28	TACTILE EGRESS SIGNAGE COMPLYING CBC SECTION 11D2-703.2 PER CBC SECTION 1011.4. SEE DETAIL 1/D02 - VEHICLY LOCATION/DESIGN WITH ARCHITECT ON SITE
29	30"x48" CLEAR SPACE
31	LINE OF EXTERIOR FINISH - CONTRACTOR TO ACCOUNT TO MATERIAL FINISH IN FRAMING DIMENSIONS AS TO NOT PROTRUDE BEYOND PROPERTY LINES.
32	LINE OF CANOPY - ON A SEPARATE ENCROACHMENT PERMIT FROM THE PUBLIC WORKS DEPARTMENT AND TYPICALLY MUST BE A MINIMUM OF 8' FROM THE EXTERIOR SURFACE OF THE STALL STRIPING.
34	E.V. CHARGING EQUIPPED PARKING, PROVIDE CLEAR LEVEL SPACE ALLOWING DRIVER OF THE VEHICLE TO SAFELY EXIT THE VEHICLE, MANUEVER TO THE CHARGING APPARATUS AND SAFELY OPERATE IT. VERIFY MAXIMUM REACH! PROVIDE CHARGING CONTROLS
35	DESIGNATED PARKING - LOW LEVEL EMITTING, FUEL-EFFICIENT, AND CARPOOL/VANPOOL VEHICLES PARKING SPACES PER CBC S.106.5.2 PARKING STALL MARKING - PAINT, IN THE PAINT USED FOR STALL STRIPING, THE FOLLOWING CHARACTERS SUCH THAT THE LOWER EDGE OF THE LAST WORD ALIGNS WITH THE TOP OF THE STALL STRIPING AND IS VISIBLE BENEATH A PARKED VEHICLE: CLEAN AIR/VAN/POOLVEY PER CBC S.106.5.2.1
37	ELECTRIC VEHICLE SUPPLY EQUIPMENT (EVSE) SEE DETAIL 6/C01

APPLIANCES SCHEDULE

AP-01	WATER FEATURE WALL
AP-02	CUSTOM GAS BURNING DIRECT VENT FIREPLACE MANUFACTURED BY HEATILATOR OR APPROVED EQUAL

PLUMBING FIXTURE SCHEDULE

PF-03	LAVATORY SINK - (SPEC'S TO FOLLOW)
-------	------------------------------------

PLUMBING CONTROL SCHEDULE

PC-03	LAVATORY SINK FAUCET AND CONTROLS - (SPEC'S TO FOLLOW)
-------	--

ENVIROTECHNO

13101 WASHINGTON BOULEVARD, #401
LOS ANGELES, CALIFORNIA 90066
310-379-9716
e-mail: luis@envirotechno.com
website: envirotechno.com

☐ 08/05/2015
☐ 12/15/2015
☐ 03/21/2016
☐ 10/10/2016
☐ 11/09/2016



HERMOSA BOUTIQUE
HOTEL, LLC
RAJU CHHABRIA & RHAVI KHOSLA
205 PER AVENUE, SUITE 201
HERMOSA BEACH, CA 90254


**HERMOSA
BOUTIQUE HOTEL**

1415 HERMOSA AVENUE
HERMOSA BEACH, CA 90254

SHEET TITLE: **GROUND LEVEL FLOOR PLAN**
 REVISION: **NOV 09 2016**
 COMMUNITY DEK DEPT.
 BUILDING RE-SUBMITTAL
 REV#05 - 11/09/2016
 JOB NO: 001-0203
 DATE: 09-17-12
 SCALE: AS NOTED
 DRAWN BY: ENM
 CHECKED BY: LDM
 SHEET NO:

A3.1

Design and specifications as instruments of service are and shall remain the property of the design professional. Duplication of the drawings and specifications without the written consent of the design professional is strictly prohibited except with specific written consent of the design professional. Any use or reproduction of this drawing in whole or in part by any means whatsoever is strictly prohibited except with specific written consent of the design professional.

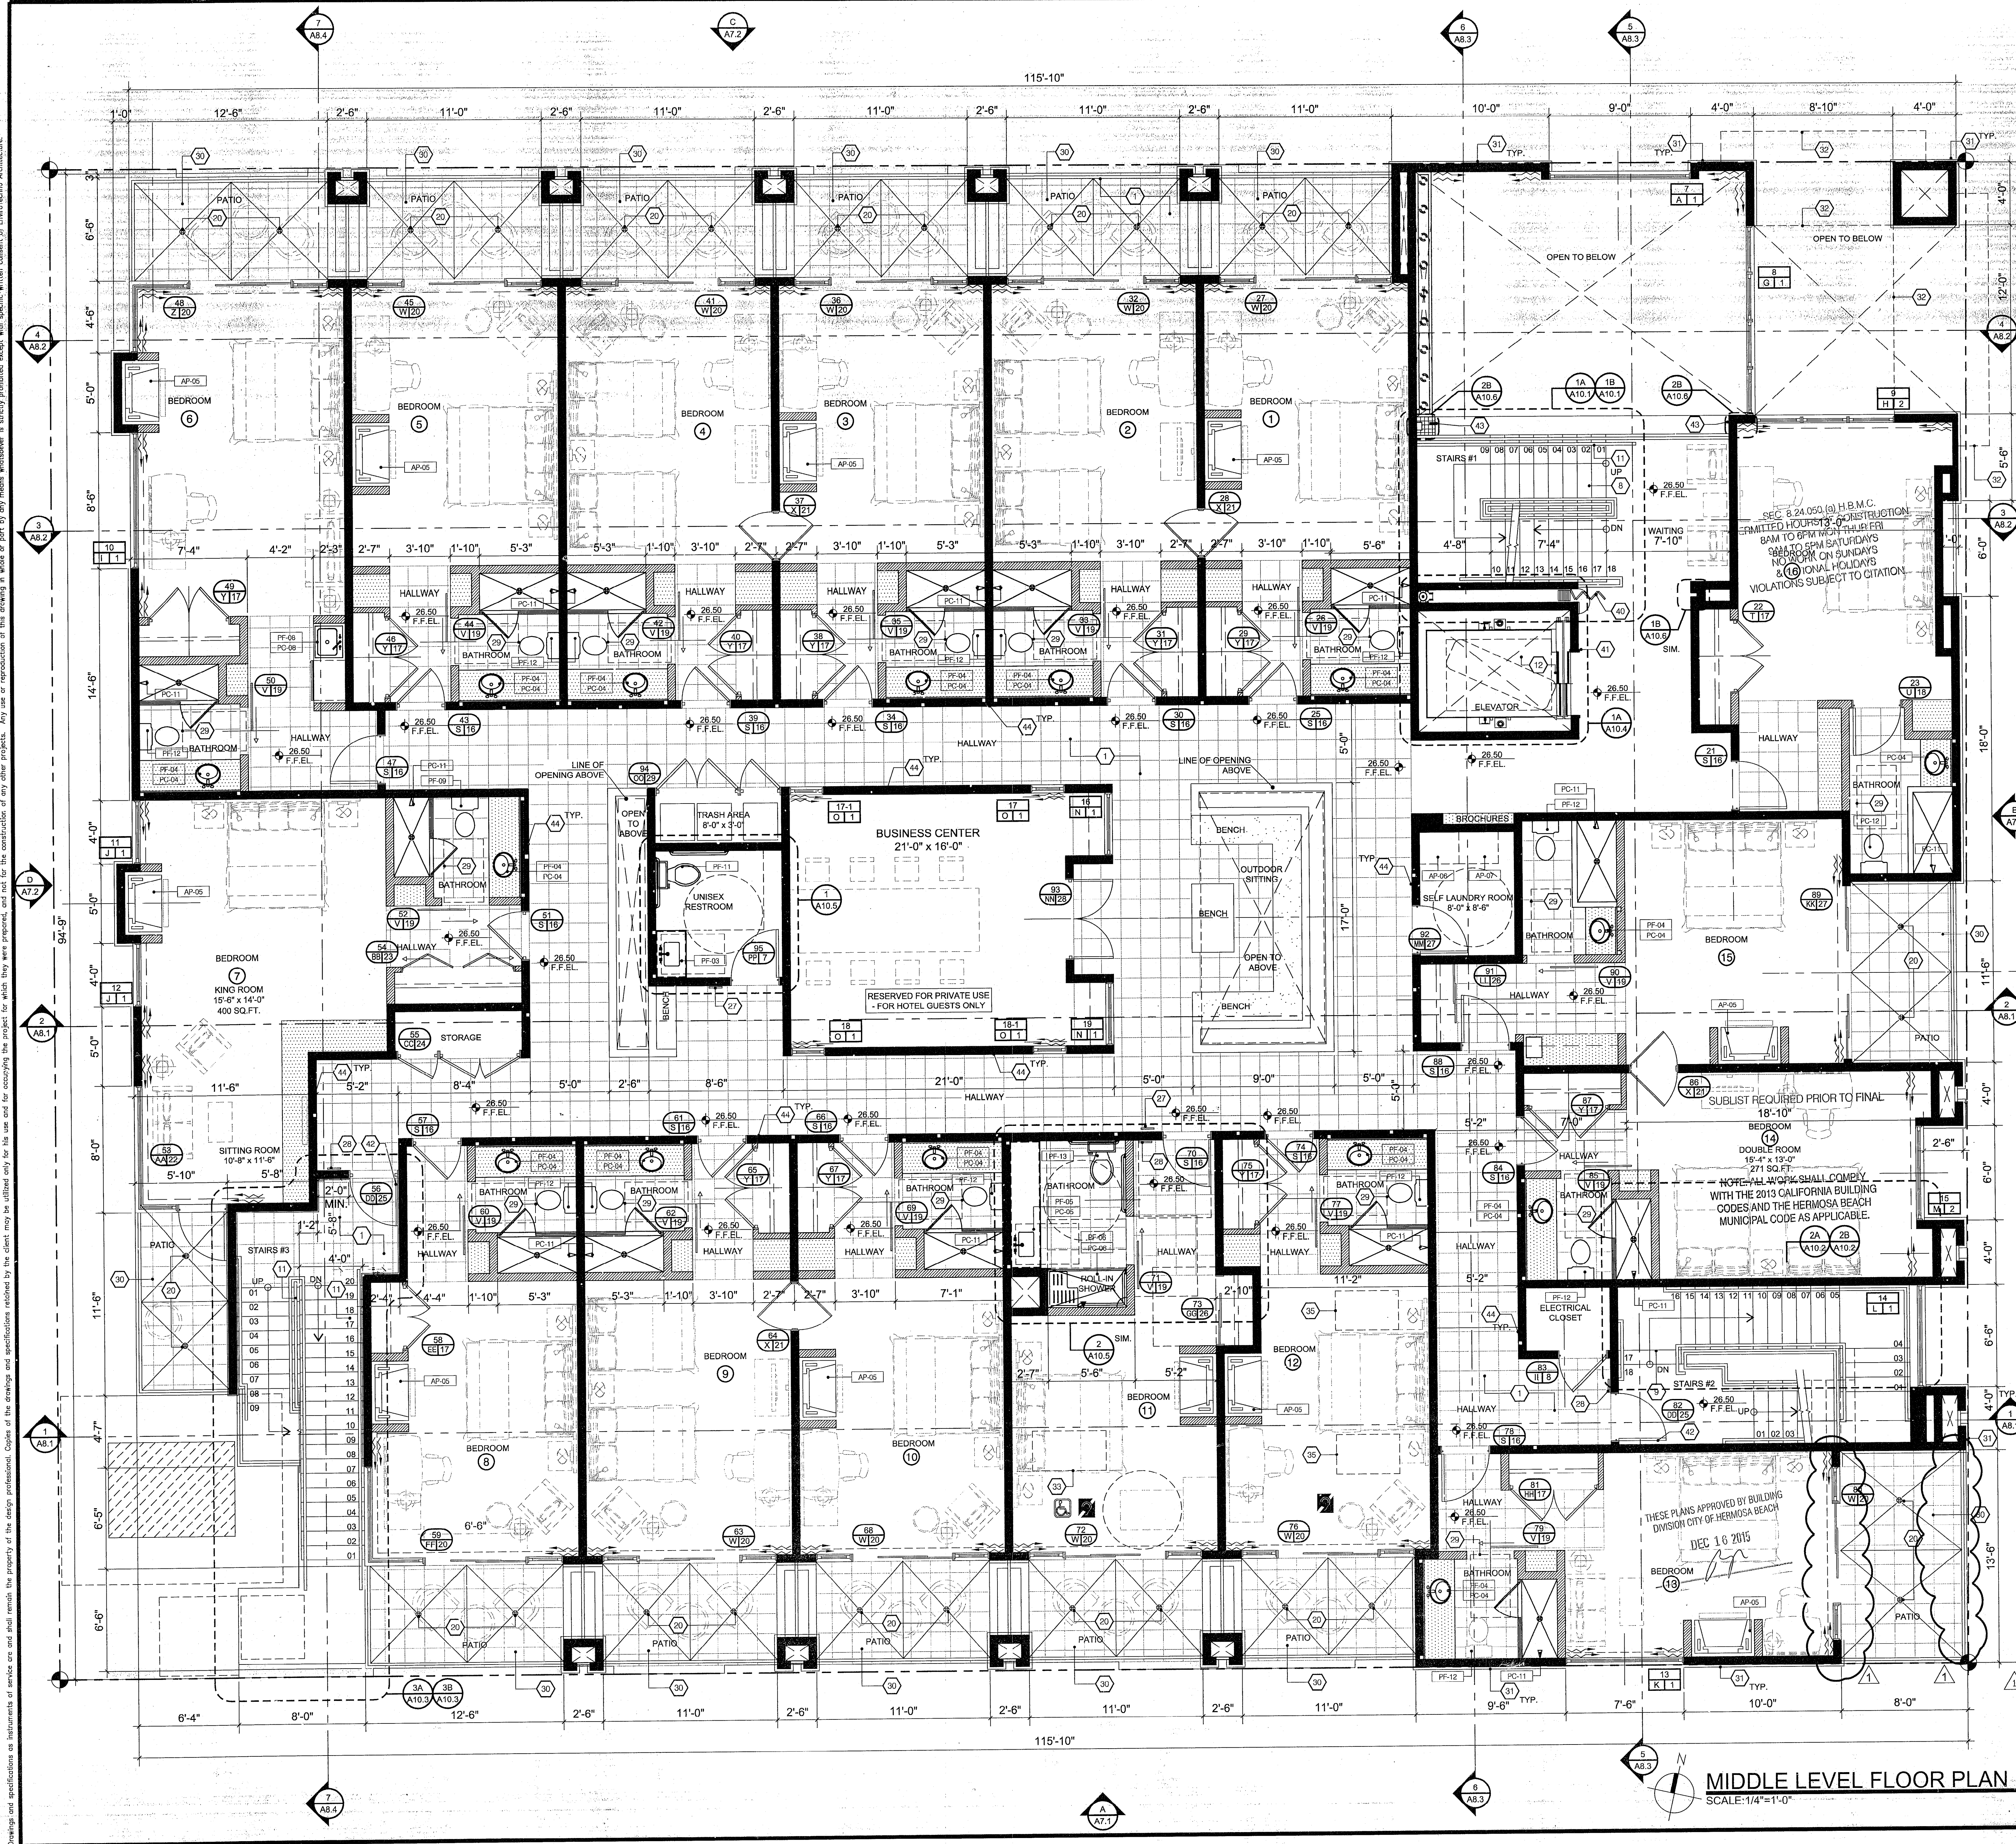

GENERAL LEGEND	
	WOOD STUD WALL 16" O.C. - U.N.O. - 1-HR. RATED WALL WITH 5/8" TYPE "X" GYP. BOARD AT INTERIOR SIDE, (SEE FINISH SCHEDULE AND INTERIOR ELEVATIONS FOR ADDITIONAL FINISHES). SEE ELEVATIONS FOR EXTERIOR FINISHES. PROVIDE SOUND ATTENUATION R-13 INSULATION (SEE STRUCTURAL DRAWINGS FOR ADDITIONAL INFORMATION).
	METAL STUD WALL 16" O.C. - U.N.O. - 1-HR. RATED WALL WITH 5/8" TYPE "X" GYP. BOARD ON BOTH SIDES.
	MILLWORK - REFER TO INTERIOR DESIGN DRAWINGS FOR DESIGN AND DETAILING.
	LANDSCAPE AREA - SEE LANDSCAPE PLANS.
	ACCESSIBLE PARKING/STREETCART - SEE SHEETS DAY 1 & DAY 2.
	PROVIDE COMMUNICATION EQUIPMENTS FOR THE HEARING IMPAIRED PER CBC TABLE 11B-224.2 & 11B-224.4.
KEY NOTES	
1. TERRAZZO FLOOR - (SPECS. TO FOLLOW)	
2. CONCRETE SLAB	
3. LANDSCAPE/PLANTING AREA - SEE LANDSCAPE PLANS	
4. CHECK IN COUNTER - INTERIOR DESIGN DRAWINGS TO FOLLOW	
5. BASE CABINET WITH STONE TOP - INTERIOR DESIGN DRAWINGS TO FOLLOW	
6. BASE CABINET WITH STONE TOP AND 6" TILE BACKSPLASH - INTERIOR DESIGN DRAWINGS TO FOLLOW	
7. UPPER CABINET - INTERIOR DESIGN DRAWINGS TO FOLLOW	
8. INTERIOR ENTRY STAIRS - INTERIOR DESIGN DRAWINGS TO FOLLOW	
9. INTERIOR EGRESS STAIRS - (SPECS. TO FOLLOW)	
10. EXTERIOR EGRESS STAIRS - (SPECS. TO FOLLOW)	
11. GUARDRAIL/HANDRAIL, MIN. 42" HIGH, SEE DETAIL 7/A-9.0	
12. ELEVATOR - TO BE ACCESSIBLE TO DISABLED PERSONS AND MEET THE STRETCHER REQUIREMENTS PER CBC SECTION 3002.4 (SPECS. TO FOLLOW). VERIFY REQ. CLEARANCES W/ ELEVATOR MFG. 1/20 MINUTE FIRE-RATED DOORS	
13. SHIELDED EXTERIOR LIGHTING - (SPECS. TO FOLLOW)	
14. BICYCLE RACK - (SPECS. TO FOLLOW) PER CBC 5.106.4.1	
15. BICYCLE RACK - (SPECS. TO FOLLOW) PER CBC 5.106.4.2	
16. TRASH/RECYCLE CONTAINER AREA	
17. TRANSFORMER/TRANSFORMER PAD - SEE EDISON DRAWINGS	
18. ELECTRICAL PANEL - SEE ELECTRICAL DRAWINGS	
19. EXTERIOR STAIRS FENCE AND GATE - (SPECS. TO FOLLOW)	
20. PROVIDE PATIO DRAIN, CONNECT TO LANDSCAPE DRAINAGE SYSTEM (REFER TO CIVIL DRAWINGS)	
21. 1-1/2" GRAB BAR - FINISH TO FOLLOW	
22. ADA REQUIRED 80/20" CLR. FLOOR SPACE CENTERED ON TRANSFER PLATFORM	
23. 24" MIN. REQUIRED WIDTH OF TRANSFER PLATFORM, 14" MIN. TO 15" MAX. AFF.	
24. STAIRS ABOVE	
25. PIT LIGHTS AND SWITCH, CONVENIENCE OUTLETS WITH GFCI PROTECTION PER NEC. PIT LADDER PER CAR (ACCORDING TO CODE) NOT BE CLEAR OF ALL ELEVATOR EQUIPMENT	
26. VALET CABINET	
27. AFFIX THE INTERNATIONAL ACCESSIBILITY SYMBOL AT ALL ACCESSIBLE ENTRANCES PER CBC SECTION 11B-208.4.11B-218.1 THE SIGN SHALL COMPLY WITH CBC SECTION 11B-703.7. THE SIGN SHALL BE LOCATED ADJACENT TO THE LATCH SIDE OF THE SINGLE DOOR AND RIGHT SIDE OF THE DOUBLE DOORS 80" AFF PER CBC SECTION 11B-703.4.1. SEE DETAIL 7/A-10.1	
28. TACTILE EGRESS SIGNAGE COMPLYING CBC SECTION 11B-703.2 PER CBC SECTION 1011.4. SEE DETAIL 10A2	
29. 30"x48" CLEAR SPACE	
30. STONE TILE FINISH OVER PACIFIC POLYMERS, ELASTO-DECK 5000 ESR-2697, COMPLETE DECK WATERPROOFING SYSTEM (OR EQUIVALENT) - SPECIFICATIONS TO FOLLOW - CONTRACTOR TO VERIFY AND PROPOSE BEST WATERPROOFING METHOD - 2% MINIMUM SLOPE TO DRAIN	
31. LINE OF METAL PANEL FINISH - CONTRACTOR TO ACCOUNT TO MATERIAL FINISH IN FRAMING DIMENSIONS AS TO NOT PROTRUDE BEYOND PROPERTY LINES	
32. LINE OF CANOPY - ON A SLOPED ENCLOSURE PERMIT FROM THE PUBLIC DEPARTMENT AND TYPICALLY MUST BE A MINIMUM OF 8" FROM THE FINISHED SURFACE ELEVATION (CURB)	
33. PROVIDE A CLEAR SPACE FOR THE PERSONAL LIFT DEVICE UNDER THE BED OF ACCESSIBLE GUESTROOM PER CBC SECTION 11B-806.2.3.1	
34. EV CHARGING EQUIPMENT PARKING, PROVIDE CLEAR LEVEL SPACE ALLOWING DRIVER OF THE VEHICLE TO SAFELY EXIT THE VEHICLE, MANEUVER TO THE CHARGING APPARATUS AND SAFELY OPERATE IT. VERIFY MAXIMUM REACH RANGE FOR CHARGING CONTROLS.	
35. 30"x48" CLEAR SPACE ON BOTH SIDES OF BED PER CBC SECTION 11B-224.3	
36. PROVIDE COMMUNICATION EQUIPMENTS FOR THE HEARING IMPAIRED PER CBC TABLE 11B-224.2 & 11B-224.4	
37. DESIGNATED PARKING FOR LOW EMISSION, FUEL-EFFICIENT, AND CARP/VANPOOL, VEHICLES PARKING SPACES PER CBC 5.106.2.2 PARKING STALL MARKING - PAINT, IN PAINT USED FOR STALL STRIPING, THE FOLLOWING CHARACTERS SUCH THAT THE LOWER EDGE OF THE LAST WORD ALIGNS WITH THE END OF THE STALL STRIPING AND IS VISIBLE BENEATH A PARKED VEHICLE: CLEAN AIR/VANPOOL/VEHICLE PER CBC 5.106.2.2.1	
38. LANDSCAPE AREA PER CBC 5.106.11 - SEE LANDSCAPE PLANS	
39. FIRE SYSTEM BACKFLOW LOCATION - VERIFY	
40. INSTALL AN AUTOMATIC CLOSING, 1-HOUR FIRE RATED HORIZONTAL ACCORDION DOOR ASSEMBLY WITH EGRESS BY MCKEON DOOR COMPANY MODEL# AC800 (CER ESR-2219, UL 10B 3-HOUR RATED, UL 1784 SMOKE & DRAFT, LARR# 25493, SEE DETAIL 1A, 1B AND 10 ON SHEET A-10.6	
41. INSTALL SMOKE GUARD MODEL# M400 ON THE 2ND AND 3RD FLOORS ONLY UL 1784 "AIR LEAKAGE TESTS OF DOOR ASSEMBLIES, UL 864" CONTROL UNITS FOR FIRE PROTECTIVE SIGNALING SYSTEMS, UL 198 (A SMOKE CONTAINMENT SYSTEM COMPLYING WITH ICC-ES AC77 ON THE 2ND AND 3RD FLOORS ONLY, CBC 713.14.1 EXCEPTION 8.)	
42. 1-HOUR FIRE ASSEMBLY PER CBC TABLE 716.5	
43. INSTALL 3-HOUR RATED OVERHEAD COILING FIRE & SMOKE RATED CEILING MOUNTED CURTAIN BY MCKEON DOOR COMPANY MODEL# D200 UL 108 & UL 10C 20-MINUTE, UL100 3-HOUR, UL 1784 SMOKE & DRAFT SEE DETAIL 2A, 2B AND 2C ON SHEET A-10.6	
44. HALLWAYS ON BOTH SECOND AND THIRD LEVELS SHALL BE ONE HOUR FIRE RATED CORRIDORS PER CBC SECTION 1018.1	
APPLIANCES SCHEDULE	
AP-01	NEW GAS BURNING FIREWALL - (SPECS TO FOLLOW)
AP-02	REFRIGERATOR - (SPECS TO FOLLOW)
AP-03	REFRIGERATOR - (SPECS TO FOLLOW)
AP-04	DISHWASHER - (SPECS TO FOLLOW)
AP-05	42" W "SPECTRA" RADIANT GAS FIREPLACE (SPECS TO FOLLOW) (APPROVED ANSI Z21.881 CSA 2.33) DIRECT-VENT, SEALED COMBUSTION TYPE PER CGCS 5.503.1
AP-06	GAS DRYER, ADA COMPLIANT - (SPECS TO FOLLOW)
AP-07	WASHER, ADA COMPLIANT - (SPECS TO FOLLOW)
PLUMBING FIXTURE SCHEDULE	
PF-01	PANTRY SINK - (SPECS TO FOLLOW)
PF-02	BREAK ROOM SINK - (SPECS TO FOLLOW)
PF-03	LAVATORY SINK - (SPECS TO FOLLOW)
PF-04	LAVATORY SINK - (SPECS TO FOLLOW)
PF-05	LAVATORY SINK - (SPECS TO FOLLOW)
PF-06	LAVATORY SINK - (SPECS TO FOLLOW)
PF-07	ACCESSIBLE ROLL-IN SHOWER - (SPECS TO FOLLOW)
PF-08	TUB - (SPECS TO FOLLOW)
PF-09	BAR SINK - (SPECS TO FOLLOW)
PF-10	BAR SINK - (SPECS TO FOLLOW)
PF-11	PATIO SINK W/ GARBAGE DISPOSAL - (SPECS TO FOLLOW)
PF-12	TOILET - (SPECS TO FOLLOW)
PF-13	TOILET - (SPECS TO FOLLOW)
PF-14	TOILET - (SPECS TO FOLLOW)
PF-15	ACCESSIBLE TUB - (SPECS TO FOLLOW)
PLUMBING CONTROL SCHEDULE	
PC-01	PANTRY SINK FAUCET AND CONTROLS - (SPECS TO FOLLOW)
PC-02	BREAK ROOM SINK FAUCET AND CONTROLS - (SPECS TO FOLLOW)
PC-03	LAVATORY SINK FAUCET AND CONTROLS - (SPECS TO FOLLOW)
PC-04	LAVATORY SINK FAUCET AND CONTROLS - (SPECS TO FOLLOW)
PC-05	LAVATORY SINK FAUCET AND CONTROLS - (SPECS TO FOLLOW)
PC-06	LAVATORY SINK FAUCET AND CONTROLS - (SPECS TO FOLLOW)
PC-07	ROLL-IN SHOWER HEAD, FAUCET AND CONTROLS - (SPECS TO FOLLOW)
PC-08	TUB FAUCET AND CONTROLS - (SPECS TO FOLLOW)
PC-09	BAR SINK FAUCET AND CONTROLS - (SPECS TO FOLLOW)
PC-10	BAR SINK FAUCET AND CONTROLS - (SPECS TO FOLLOW)
PC-11	PATIO SINK FAUCET AND CONTROLS - (SPECS TO FOLLOW)
PC-12	SHOWER HEAD AND CONTROLS FAUCET AND CONTROLS - (SPECS TO FOLLOW)
PC-13	SHOWER HEAD AND CONTROLS FAUCET AND CONTROLS - (SPECS TO FOLLOW)
PC-14	MESSAGE ROOM SINK FAUCET AND CONTROLS - (SPECS TO FOLLOW)
PC-15	TUB SHOWER HEAD, FAUCET AND CONTROLS - (SPECS TO FOLLOW)

ENVIROTECHNO

INTERACTIVE ARCHITECTURE +
13101 WASHINGTON BOULEVARD, #400
LOS ANGELES, CALIFORNIA 90066
310-377-7873 VOICE
e-mail: info@envirotechno.com
website: envirotechno.com

08/05/2015

HERMOSA BOUTIQUE HOTEL, LLC

RAVI CHHABRIA & RAVI KHOSLA
205 PIER AVENUE, SUITE 201
HERMOSA BEACH, CA 90254

CLIENT NAME:

PROJECT TITLE:

MIDDLE LEVEL FLOOR PLAN

REVISION #1 - 08/05/2015
PLAN CHECK RESUBMITTAL - 12/02/15

JOB NO:

DATE:

SCALE:

DRAWN BY:

CHECKED BY:

SHEET NO:

0012-03

08-17-12


AS NOTED

ENM

LDM

A3.2

Drawings and specifications are instruments of service and shall remain the property of the design professional. Copies of the drawings and specifications released by the client may be utilized only for the use and for completing the project for which they were intended, and not for the construction of any other project. Any use or reproduction of the drawings or specifications for any other project without the written consent of the design professional is strictly prohibited and will result in legal action.

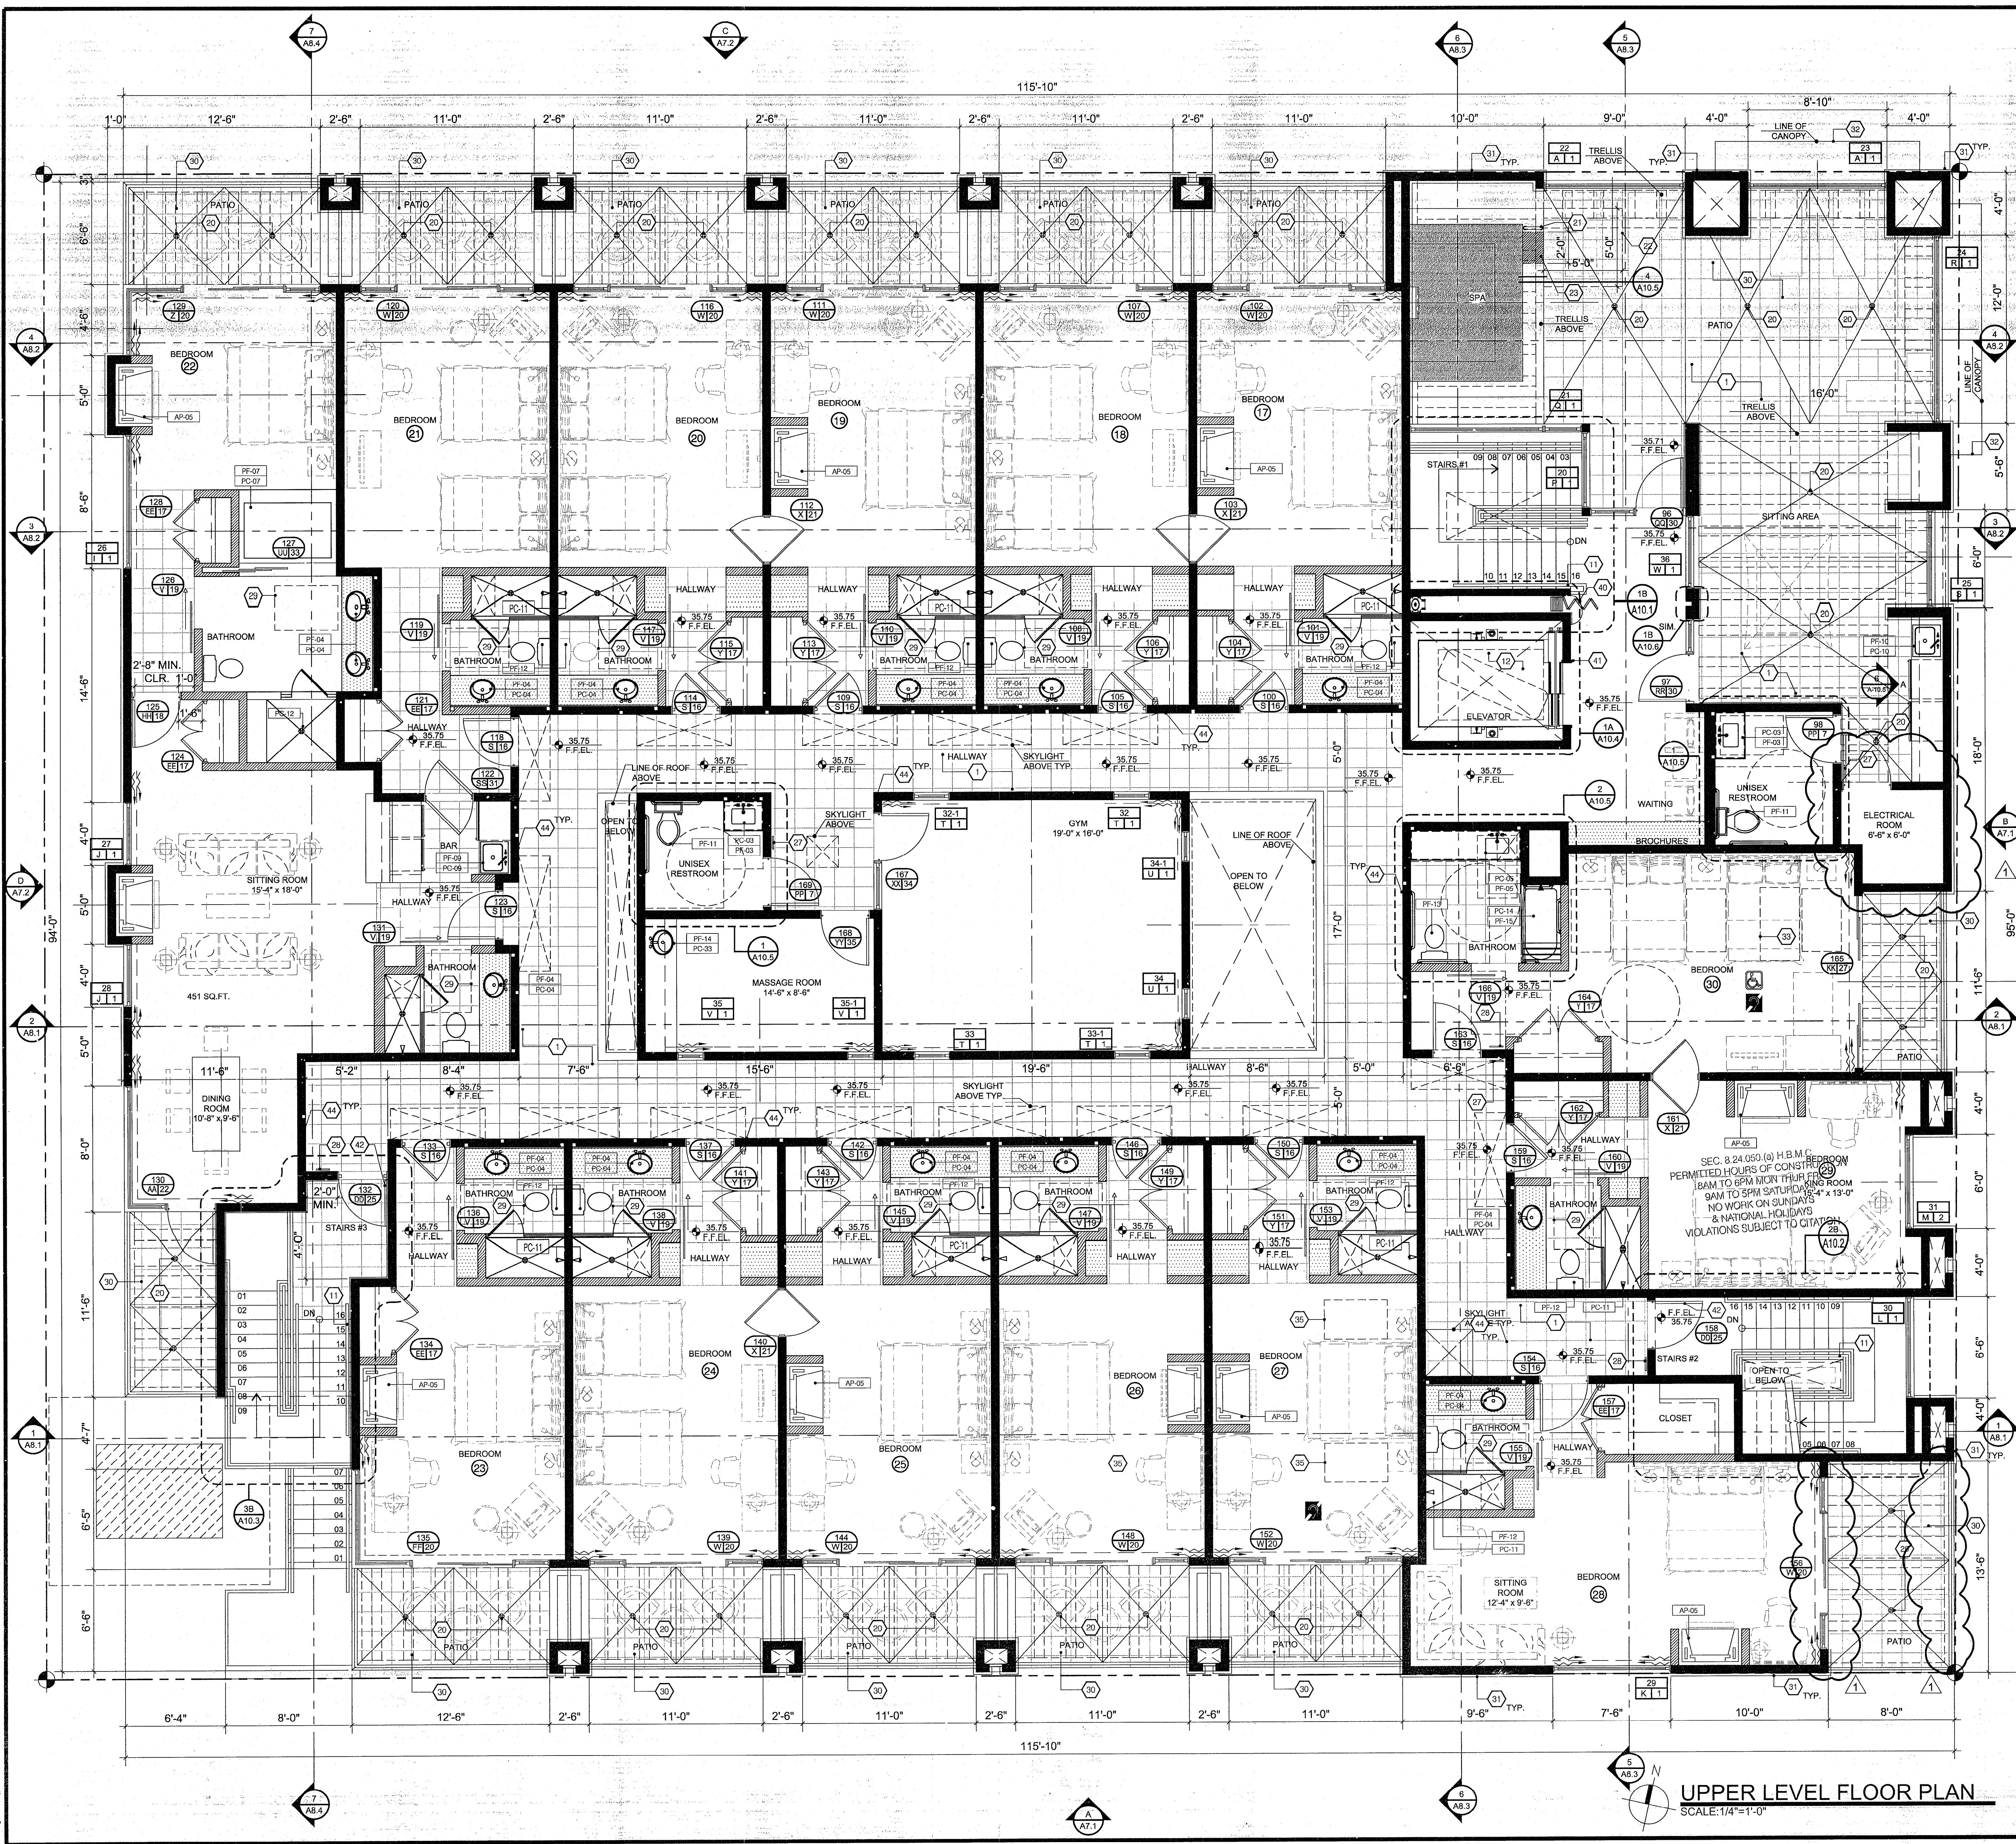

GENERAL LEGEND

WOOD STUD WALL 16" O.C. - U.N.O. - 1-HR. RATED WALL WITH 5/8" TYPE "X" GYP. BOARD AT INTERIOR SIDE. (SEE FINISH SCHEDULE AND INTERIOR ELEVATIONS FOR ADDITIONAL FINISHES). SEE ELEVATIONS FOR EXTERIOR FINISHES. PROVIDE SOUND ATTENUATION INSULATION SEE STRUCTURAL DRAWINGS FOR ADDITIONAL INFORMATION.

WOOD STUD WALL 16" O.C. - U.N.O. - WITH 5/8" GYP. BOARD ON BOTH SIDES.

METAL STUD WALL 16" O.C. - U.N.O. - 1-HR. RATED WALL WITH 5/8" TYPE "X" GYP. BOARD ON BOTH SIDES.

LANDSCAPE AREA - SEE LANDSCAPE PLANS.

ACCESSIBLE PARKING/QUESTRROOM - SEE SHEETS DA1 & DA2.

PROVIDE COMMUNICATION EQUIPMENTS FOR THE HEARING IMPAIRED PER CBC TABLE 11B-224.2 & 11B-224.4.

KEY NOTES

- TERRAZZO FLOOR - (SPECS. TO FOLLOW)
- CONCRETE SLAB
- LANDSCAPE/PLAN TING AREA - SEE LANDSCAPE PLANS
- CHECK IN COUNTER - INTERIOR DESIGN DRAWINGS TO FOLLOW
- BASE CABINET WITH STONE TOP - INTERIOR DESIGN DRAWINGS TO FOLLOW
- BASE CABINET WITH STONE TOP AND 6" TILE BACKPLASH - INTERIOR DESIGN DRAWINGS TO FOLLOW
- UPPER CABINET - INTERIOR DESIGN DRAWINGS TO FOLLOW
- INTERIOR ENTRY STAIRS - INTERIOR DESIGN DRAWINGS TO FOLLOW
- INTERIOR EGRESS STAIRS - (SPECS. TO FOLLOW)
- EXTERIOR EGRESS STAIRS - (SPECS. TO FOLLOW)
- GUARDRAIL/HANDRAIL, MIN. 42" HIGH, SEE DETAIL 7/A-9.0
- ELEVATOR - TO BE ACCESSIBLE TO DISABLED PERSONS AND MEET THE STRETCHER REQUIREMENTS PER CBC SECTION 302.4 (SPECS. TO FOLLOW). VERIFY REQ. CLEARANCES W/ ELEVATOR MFG. W/ 20 MINUTE FIRE RATED DOORS
- SHIELDED EXTERIOR LIGHTING - (SPECS. TO FOLLOW)
- BICYCLE RACK - (SPECS. TO FOLLOW) PER CBC 5.106.4.1
- BICYCLE RACK - (SPECS. TO FOLLOW) PER CBC 5.106.4.2
- TRASH/RECYCLE CONTAINER AREA
- TRANSFORMER/TRANSFORMER PAD - SEE EDISON DRAWINGS
- ELECTRICAL PANEL - SEE ELECTRICAL DRAWINGS
- EXTERIOR STAIRS FENCE AND GATE - (SPECS. TO FOLLOW)
- PROVIDE PATIO DRAIN, CONNECT TO LANDSCAPE DRAINAGE SYSTEM (REFER TO CIVIL DRAWINGS)
- 1-1/2" GRAB BAR - FINISH TO FOLLOW
- ADA REQUIRED 60"x80" CLR. FLOOR SPACE CENTERED ON TRANSFER PLATFORM
- 24" MIN. REQUIRED WIDTH OF TRANSFER PLATFORM, 14" MIN. TO 19" MAX. AFF.
- STAIRS ABOVE
- PIT LIGHTS AND SWITCH, CONVENIENCE OUTLETS WITH GFCI PROTECTION PER NEC, PIT LADDER PER CAR (ACCORDING TO CODE) NOTE: MUST BE CLEAR OF ALL ELEVATOR EQUIPMENT
- VALET CABINET
- VERIFY THE INTERNATIONAL ACCESSIBILITY SYMBOL AT ALL ACCESSIBLE ENTRANCES PER CBC SECTION 11B-208.4(1) & 11B-216.8. THE SIGN SHALL COMPLY WITH CBC SECTION 11B-703.7. THE SIGN SHALL BE LOCATED ADJACENT TO THE LATCH SIDE OF THE SINGLE DOOR AND RIGHT SIDE OF THE DOUBLE DOORS 60" AFF PER CBC SECTION 11B-703.4.1. SEE DETAIL 10A2
- BOTTLE EGRESS SIGNAGE COMPLYING CBC SECTION 11B-703.2 PER CBC SECTION 1011.4. SEE DETAIL 10A2
- 30"x48" CLEAR SPACE
- STONE TILE FINISH OVER PACIFIC POLYMERS, ELASTO-DECK 5000 ESR-2887, COMPLETE DECK WATERPROOFING SYSTEM (OR EQUIVALENT). SPECIFICATION: 3 TO FOLLOW - CONTRACTOR TO VERIFY AND PROPOSE BEST WATERPROOFING METHOD - 2% MINIMUM SLOPE TO DRAIN
- LINE OF METAL PANEL FINISH - CONTRACTOR TO ACCOUNT TO MATERIAL FINISH IN FRAMING DIMENSIONS AS TO NOT PROTRUDE BEYOND PROPERTY LINES.
- LINE OF CANOPY - ON A SEPARATE ENCROACHMENT PERMIT FROM THE PUBLIC WORKS DEPARTMENT AND TYPICALLY SHALL BE A MINIMUM OF 8' FROM THE FINISHED SURFACE ELEVATION (CURB).
- PROVIDE A CLEAR SPACE FOR THE PERSONAL LIFT DEVICE UNDER THE BED OF ACCESSIBLE GUESTROOMS PER CBC SECTION 11B-809.2.3.1.
- EV CHARGING EQUIPPED PARKING, PROVIDE CLEAR LEVEL SPACE ALLOWING DRIVER OF THE VEHICLE TO SAFELY EXIT THE VEHICLE, MANEUVER TO THE CHARGING APPARATUS AND SAFELY OPERATE IT. VERIFY MAXIMUM RANGE FOR CHARGING CONTROLS.
- 30"x48" CLEAR SPACE ON BOTH SIDES OF BED PER CBC SECTION 11B-224.3.
- PROVIDE COMMUNICATION EQUIPMENTS FOR THE HEARING IMPAIRED PER CBC TABLE 11B-224.2 & 11B-224.4.
- DESIGNATED PARKING FOR LOW EMITTING, FUEL-EFFICIENT, AND CARPOOL/VANPOOL VEHICLES PARKING SPACES PER CBC 5.106.5.2 PARKING STALL MARKING - PAINT IN THE PAINT USED FOR STALL STRIPING, THE FOLLOWING CHARACTERS SUCH THAT THE LOWER EDGE OF THE LAST WORD ALIGNS WITH THE END OF THE STALL STRIPING AND IS VISIBLE BENEATH A PARKED VEHICLE: CLEAN ARABIAN/POLEV PER CBC 5.106.5.2.1.
- EV CHARGING EQUIPPED PARKING (EVS) SEE NOTE 60M1
- LANDSCAPE AREA PER CBC 5.106.11 - SEE LANDSCAPE PLANS
- FIRE SYSTEM BACKFLOW LOCATION - VERIFY
- INSTALL AN AUTOMATIC CLOSING, 1-HOUR FIRE RATED HORIZONTAL ACCORDION DOOR ASSEMBLY WITH EGRESS BY MCKEON DOOR COMPANY MODEL ACR800 ICF ESR-2219, UL 108 3-HOUR RATED, UL 1784 SMOKE AND DRAFT, LARRE 25493. SEE DETAIL 1A, 1B AND 10 ON SHEET A-10.8
- INSTALL SMOKE GUARD MODEL M400 ON THE 2ND AND 3RD FLOORS ONLY UL 1784 "AIR LEAKAGE TESTS OF DOOR ASSEMBLIES", UL 864 "CONTROL UNITS FOR FIRE PROTECTIVE SIGNALING SYSTEMS", ICF ESR-1186 A SMOKE CONTAINMENT SYSTEM COMPLYING WITH ICF 8.4.77 ON THE 2ND AND 3RD FLOORS ONLY, CBC 713.14.1 (EXCEPTION 8.)
- 1-HOUR FIRE ASSEMBLY PER CBC TABLE 716.5
- INSTALL 3-HOUR RATED OVERHEAD COG FIVE 8" SMOKE RATED CEILING MOUNTED CURTAIN BY MCKEON DOOR COMPANY MODEL D200 UL 108 & UL 10C 20-MINUTE, UL100 3-HOUR, UL 1784 SMOKE & DRAFT SEE DETAIL 2A, 2B AND 2C ON SHEET A-10.8
- HALLWAYS ON BOTH SECOND AND THIRD LEVELS SHALL BE ONE HOUR FIRE RATED CORRIDORS PER CBC SECTION 1018.1.

APPLIANCES SCHEDULE

AP-01	NEW GAS BURNING FIREWALL - (SPECS TO FOLLOW)
AP-02	REFRIGERATOR - (SPECS TO FOLLOW)
AP-03	REFRIGERATOR - (SPECS TO FOLLOW)
AP-04	DISHWASHER - (SPECS TO FOLLOW)
AP-05	42" W SPECTER - RADIANT GAS FIREPLACE (SPECS TO FOLLOW) (APPROVED ANSI Z21 881 CSA 2.33) DIRECT-VENT, SEALED COMBUSTION TYPE PER CBC 5.503.1
AP-06	GAS DRYER, ADA COMPLIANT - (SPECS TO FOLLOW)
AP-07	WASHER, ADA COMPLIANT - (SPECS TO FOLLOW)

PLUMBING FIXTURE SCHEDULE

PF-01	PANTRY SINK - (SPECS TO FOLLOW)
PF-02	BREAK ROOM SINK - (SPECS TO FOLLOW)
PF-03	LAVATORY SINK - (SPECS TO FOLLOW)
PF-04	LAVATORY SINK - (SPECS TO FOLLOW)
PF-05	LAVATORY SINK - (SPECS TO FOLLOW)
PF-06	ACCESSIBLE ROLL-IN SHOWER - (SPECS TO FOLLOW)
PF-07	TUB - (SPECS TO FOLLOW)
PF-08	BAR SINK - (SPECS TO FOLLOW)
PF-09	BAR SINK - (SPECS TO FOLLOW)
PF-10	PATIO SINK W/ GARBAGE DISPOSAL - (SPECS TO FOLLOW)
PF-11	TOILET - (SPECS TO FOLLOW)
PF-12	TOILET - (SPECS TO FOLLOW)
PF-13	TOILET - (SPECS TO FOLLOW)
PF-14	MESSAGE ROOM SINK - (SPECS TO FOLLOW)
PF-15	ACCESSIBLE TUB - (SPECS TO FOLLOW)

PLUMBING CONTROLS SCHEDULE

PC-01	PANTRY SINK FAUCET AND CONTROLS - (SPECS TO FOLLOW)
PC-02	LAVATORY SINK FAUCET AND CONTROLS - (SPECS TO FOLLOW)
PC-03	LAVATORY SINK FAUCET AND CONTROLS - (SPECS TO FOLLOW)
PC-04	LAVATORY SINK FAUCET AND CONTROLS - (SPECS TO FOLLOW)
PC-05	LAVATORY SINK FAUCET AND CONTROLS - (SPECS TO FOLLOW)
PC-06	ROLL-IN SHOWER HEAD, FAUCET AND CONTROLS - (SPECS TO FOLLOW)
PC-07	TUB FAUCET AND CONTROLS - (SPECS TO FOLLOW)
PC-08	BAR SINK FAUCET AND CONTROLS - (SPECS TO FOLLOW)
PC-09	BAR SINK FAUCET AND CONTROLS - (SPECS TO FOLLOW)
PC-10	PATIO SINK FAUCET AND CONTROLS - (SPECS TO FOLLOW)
PC-11	SHOWER HEAD AND CONTROLS FAUCET AND CONTROLS - (SPECS TO FOLLOW)
PC-12	SHOWER HEAD AND CONTROLS FAUCET AND CONTROLS - (SPECS TO FOLLOW)
PC-13	MESSAGE ROOM SINK FAUCET AND CONTROLS - (SPECS TO FOLLOW)
PC-14	TUB SHOWER HEAD, FAUCET AND CONTROLS - (SPECS TO FOLLOW)

ENVIROTECHNO

INTERACTIVE ARCHITECTURE + INTERIOR DESIGN

13101 WASHINGTON BOULEVARD, #404
LOS ANGELES, CALIFORNIA 90068
310-377-7873 VOICE
e-mail: luis@envirotechno.com
website: envirotechno.com

08/05/2015

08/05/2015

08/05/2015

HERMOSA BOUTIQUE HOTEL, LLC

RAJU CHABRIA & RAHVI KHOSLA
205 PIER AVENUE, SUITE 204
HERMOSA BEACH, CA 90254

HERMOSA BOUTIQUE HOTEL

1429 HERMOSA AVENUE
HERMOSA BEACH, CA 90254

CLIENT NAME: **HERMOSA BOUTIQUE HOTEL, LLC**

PROJECT TITLE: **UPPER LEVEL FLOOR PLAN**

THESE PLANS APPROVED BY BUILDING DIVISION CITY OF HERMOSA BEACH

DEC 16 2015

DEC 03 2015

DATE: DEC 03 2015

NOTE: ALL WORK SHALL COMPLY WITH THE 2013 CALIFORNIA BUILDING CODES AND ALL APPLICABLE LOCAL ORDINANCES. RECOMMENDATION IS HEREBY MADE THAT THE CLIENT OBTAIN A PERMIT FROM THE CITY OF HERMOSA BEACH FOR THE CONSTRUCTION OF THE PROJECT.

SUBMIT REQUIRED PRIOR TO FINAL

REVISION 1 - 08/05/2015

PLAN CHECK RESUBMITTAL - 12/02/15

JOB NO: 0012-03

DATE: 09-17-12

SCALE: AS NOTED


DRAWN BY: ENM

CHECKED BY: LDM

SHEET NO: 1

A3.3

Developing and specifications or instruments of service are not and shall remain the property of the design professional. Copies of the drawings and specifications obtained by the client may be utilized only for the use and for copying the project which they were prepared, and not for the construction of any other projects. Any use or reproduction of this drawing in whole or part by any person whatsoever is strictly prohibited except with written consent of Envirotechno, Inc.

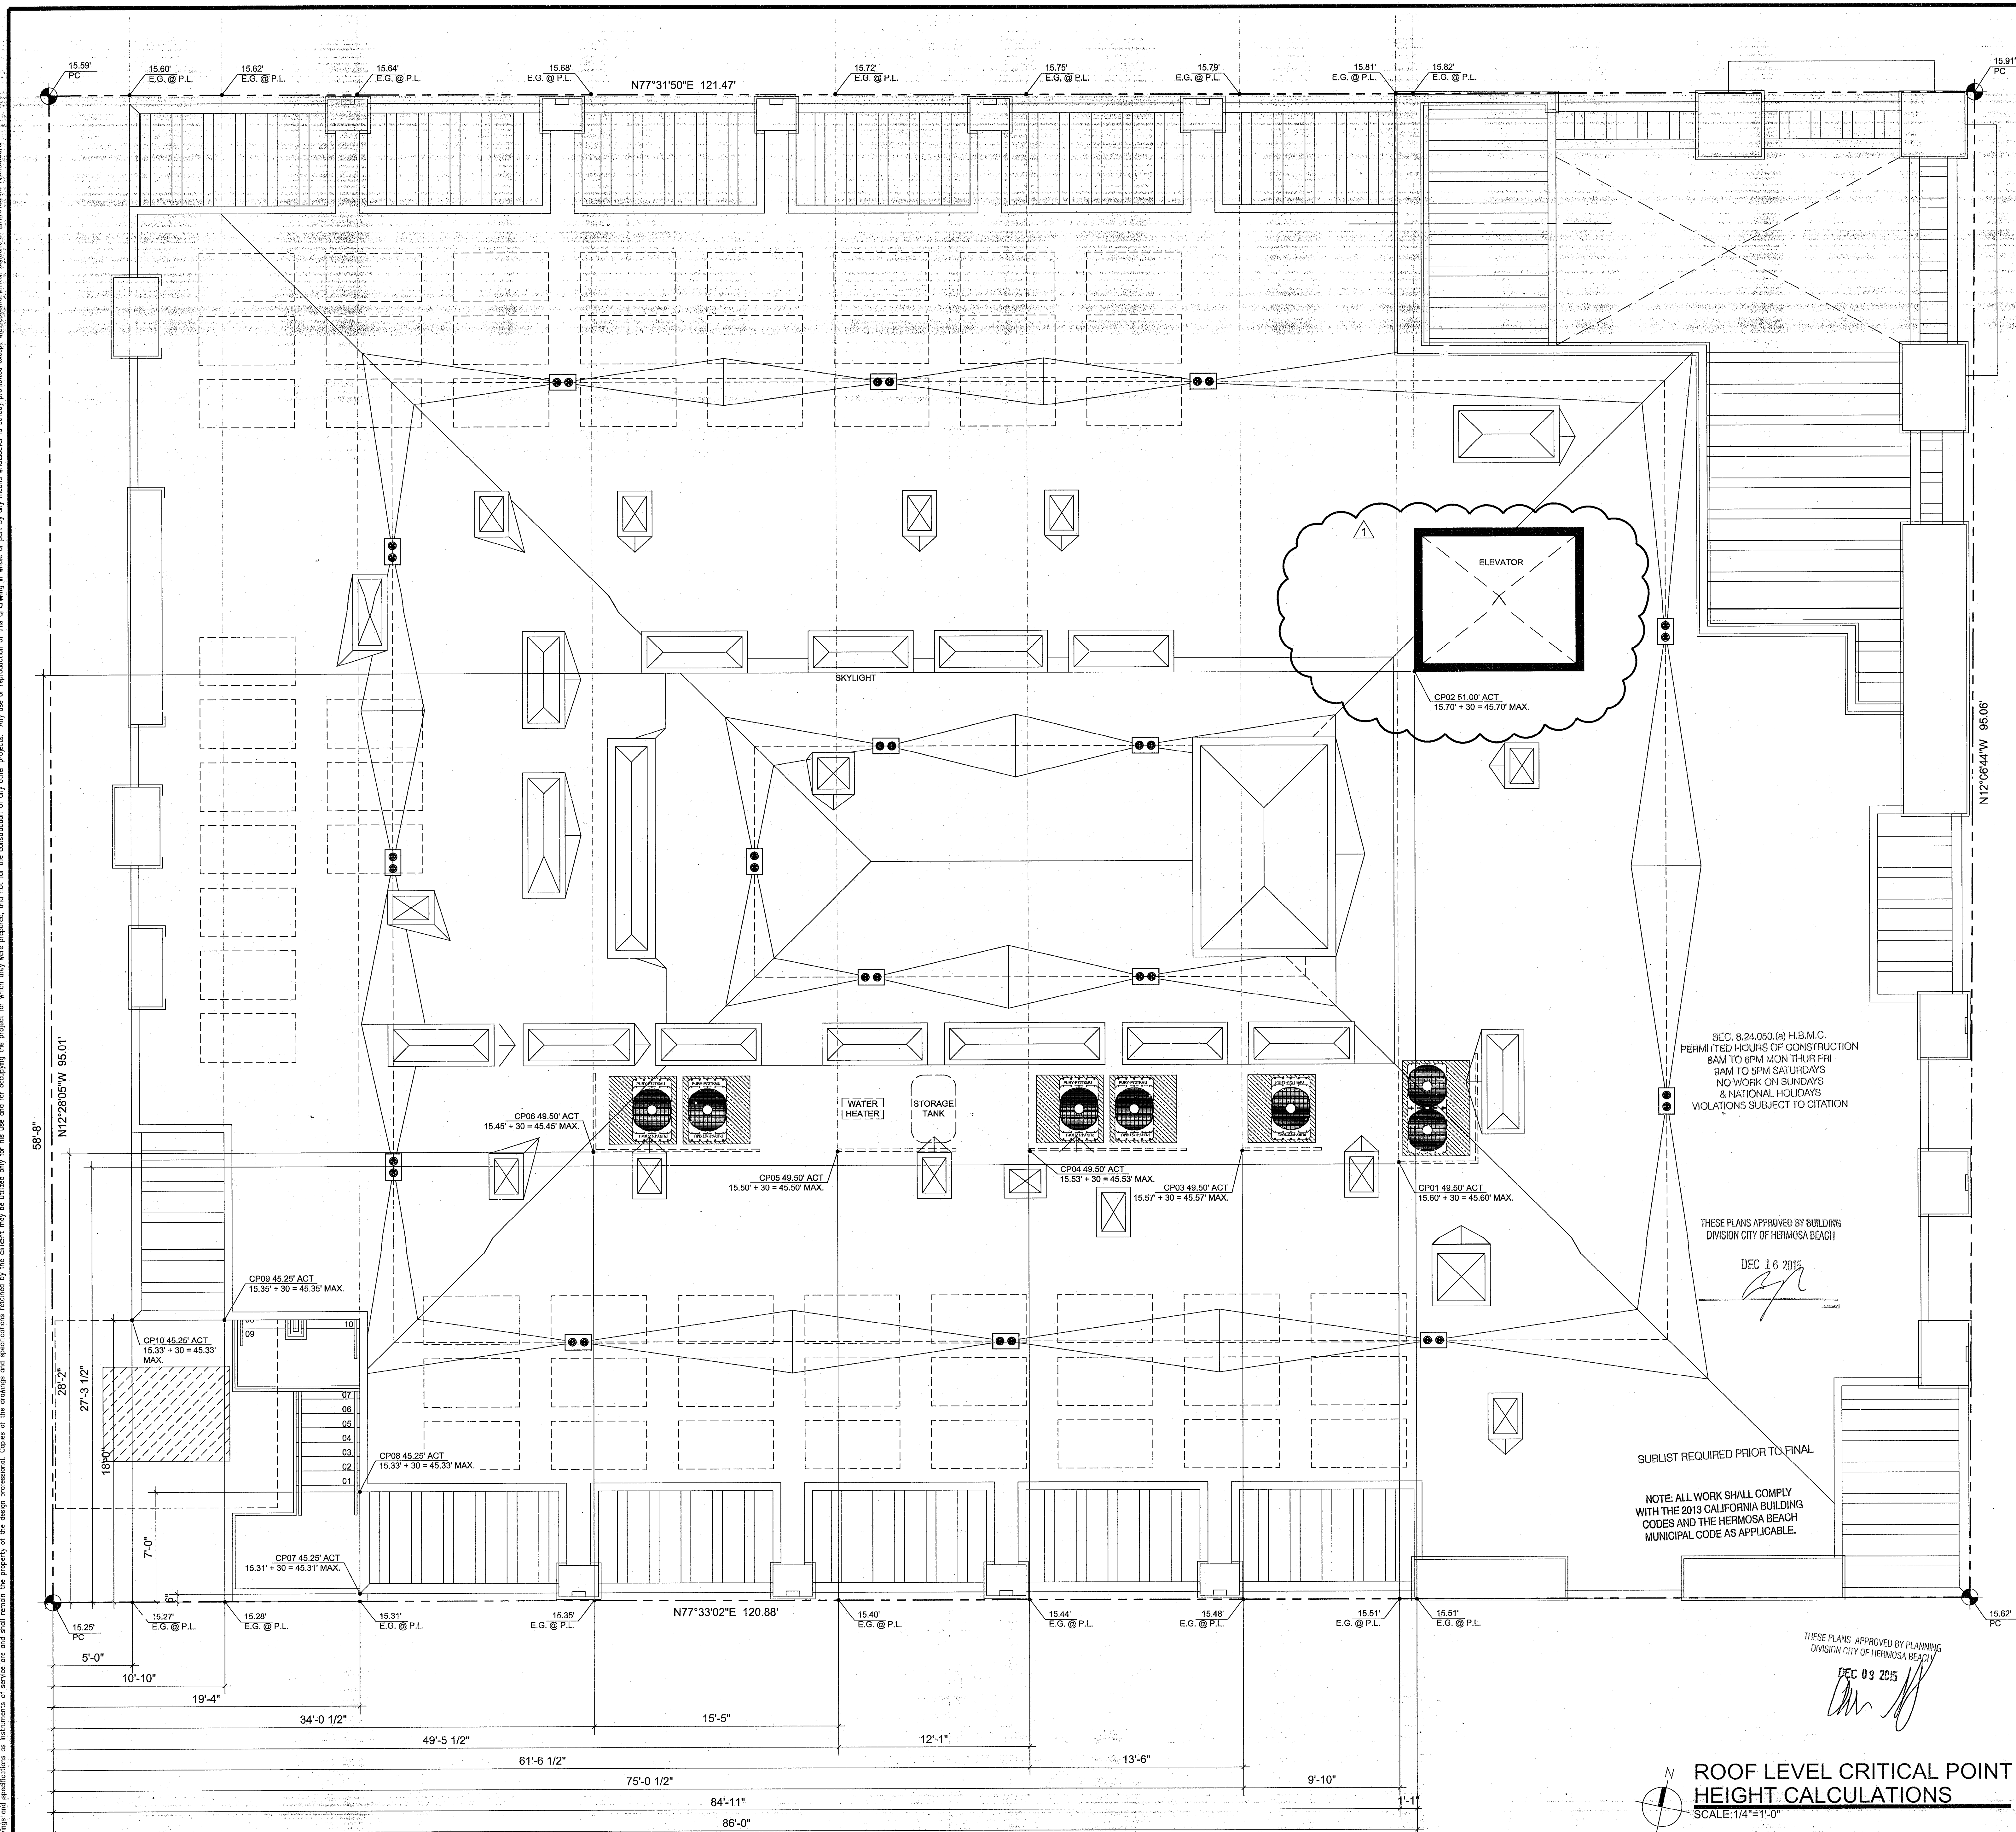

CRITICAL POINT HEIGHT CALCULATIONS

SLOPE AT PROPERTY LINE	
NORTH SIDE	SOUTH SIDE
15.91 HIGH CORNER	15.91 HIGH CORNER
15.59 LOW CORNER	15.25 LOW CORNER
0.32 DIFFERENCE	0.37 DIFFERENCE
121.47 LOT DEPTH	120.88 LOT DEPTH
0.0026 SLOPE PER FOOT	0.0031 SLOPE PER FOOT
CRITICAL POINT 01	
84.92 DISTANCE FROM LOW POINT	84.92 DISTANCE FROM LOW POINT
0.22 RISE ALONG P.L.	0.28 RISE ALONG P.L.
15.59 LOW CORNER	15.25 LOW CORNER
15.81 P.L. ELEV. AT C.P.	15.81 P.L. ELEV. AT C.P.
CROSS LOT	
15.81 NORTH SIDE ELEV. AT C.P.	0.09 TOTAL RISE TO C.P. (GROUND LEVEL)
15.51 SOUTH SIDE ELEV. AT C.P.	15.51 SOUTH SIDE ELEV. AT C.P.
0.3038 DIFFERENCE	15.60 GROUND ELEV. UNDER C.P.
95.01 LOT DEPTH	30 HEIGHT LIMIT
0.0033 SLOPE PER FOOT	45.60 MAX. HEIGHT LIMIT AT C.P.
27.23 DISTANCE SOUTH SIDE TO C.P.	
CRITICAL POINT 02	
NORTH SIDE	SOUTH SIDE
85.00 DISTANCE FROM LOW POINT	85.00 DISTANCE FROM LOW POINT
0.23 RISE ALONG P.L.	0.28 RISE ALONG P.L.
15.59 LOW CORNER	15.25 LOW CORNER
15.82 P.L. ELEV. AT C.P.	15.81 P.L. ELEV. AT C.P.
CROSS LOT	
15.82 NORTH SIDE ELEV. AT C.P.	0.19 TOTAL RISE TO C.P. (GROUND LEVEL)
15.51 SOUTH SIDE ELEV. AT C.P.	15.51 SOUTH SIDE ELEV. AT C.P.
0.3038 DIFFERENCE	15.57 GROUND ELEV. UNDER C.P.
95.01 LOT DEPTH	30 HEIGHT LIMIT
0.0032 SLOPE PER FOOT	45.70 MAX. HEIGHT LIMIT AT C.P.
58.67 DISTANCE SOUTH SIDE TO C.P.	
CRITICAL POINT 03	
NORTH SIDE	SOUTH SIDE
75.04 DISTANCE FROM LOW POINT	75.04 DISTANCE FROM LOW POINT
0.20 RISE ALONG P.L.	0.23 RISE ALONG P.L.
15.59 LOW CORNER	15.25 LOW CORNER
15.79 P.L. ELEV. AT C.P.	15.48 P.L. ELEV. AT C.P.
CROSS LOT	
15.79 NORTH SIDE ELEV. AT C.P.	0.09 TOTAL RISE TO C.P. (GROUND LEVEL)
15.48 SOUTH SIDE ELEV. AT C.P.	15.48 SOUTH SIDE ELEV. AT C.P.
0.3038 DIFFERENCE	15.57 GROUND ELEV. UNDER C.P.
95.01 LOT DEPTH	30 HEIGHT LIMIT
0.0032 SLOPE PER FOOT	45.57 MAX. HEIGHT LIMIT AT C.P.
28.17 DISTANCE SOUTH SIDE TO C.P.	
CRITICAL POINT 04	
NORTH SIDE	SOUTH SIDE
91.54 DISTANCE FROM LOW POINT	91.54 DISTANCE FROM LOW POINT
0.16 RISE ALONG P.L.	0.19 RISE ALONG P.L.
15.59 LOW CORNER	15.25 LOW CORNER
15.75 P.L. ELEV. AT C.P.	15.44 P.L. ELEV. AT C.P.
CROSS LOT	
15.75 NORTH SIDE ELEV. AT C.P.	0.09 TOTAL RISE TO C.P. (GROUND LEVEL)
15.44 SOUTH SIDE ELEV. AT C.P.	15.44 SOUTH SIDE ELEV. AT C.P.
0.3138 DIFFERENCE	15.53 GROUND ELEV. UNDER C.P.
95.01 LOT DEPTH	30 HEIGHT LIMIT
0.0033 SLOPE PER FOOT	45.53 MAX. HEIGHT LIMIT AT C.P.
28.17 DISTANCE SOUTH SIDE TO C.P.	
CRITICAL POINT 05	
NORTH SIDE	SOUTH SIDE
49.46 DISTANCE FROM LOW POINT	49.46 DISTANCE FROM LOW POINT
0.13 RISE ALONG P.L.	0.15 RISE ALONG P.L.
15.59 LOW CORNER	15.25 LOW CORNER
15.72 P.L. ELEV. AT C.P.	15.40 P.L. ELEV. AT C.P.
CROSS LOT	
15.72 NORTH SIDE ELEV. AT C.P.	0.09 TOTAL RISE TO C.P. (GROUND LEVEL)
15.40 SOUTH SIDE ELEV. AT C.P.	15.40 SOUTH SIDE ELEV. AT C.P.
0.3189 DIFFERENCE	15.50 GROUND ELEV. UNDER C.P.
95.01 LOT DEPTH	30 HEIGHT LIMIT
0.0034 SLOPE PER FOOT	45.50 MAX. HEIGHT LIMIT AT C.P.
28.17 DISTANCE SOUTH SIDE TO C.P.	
CRITICAL POINT 06	
NORTH SIDE	SOUTH SIDE
34.04 DISTANCE FROM LOW POINT	34.04 DISTANCE FROM LOW POINT
0.09 RISE ALONG P.L.	0.10 RISE ALONG P.L.
15.59 LOW CORNER	15.25 LOW CORNER
15.68 P.L. ELEV. AT C.P.	15.35 P.L. ELEV. AT C.P.
CROSS LOT	
15.68 NORTH SIDE ELEV. AT C.P.	0.10 TOTAL RISE TO C.P. (GROUND LEVEL)
15.35 SOUTH SIDE ELEV. AT C.P.	15.35 SOUTH SIDE ELEV. AT C.P.
0.3285 DIFFERENCE	15.45 GROUND ELEV. UNDER C.P.
95.01 LOT DEPTH	30 HEIGHT LIMIT
0.0034 SLOPE PER FOOT	45.45 MAX. HEIGHT LIMIT AT C.P.
28.17 DISTANCE SOUTH SIDE TO C.P.	
CRITICAL POINT 07	
NORTH SIDE	SOUTH SIDE
19.33 DISTANCE FROM LOW POINT	19.33 DISTANCE FROM LOW POINT
0.06 RISE ALONG P.L.	0.06 RISE ALONG P.L.
15.59 LOW CORNER	15.25 LOW CORNER
15.64 P.L. ELEV. AT C.P.	15.31 P.L. ELEV. AT C.P.
CROSS LOT	
15.64 NORTH SIDE ELEV. AT C.P.	0.00 TOTAL RISE TO C.P. (GROUND LEVEL)
15.31 SOUTH SIDE ELEV. AT C.P.	15.31 SOUTH SIDE ELEV. AT C.P.
0.3318 DIFFERENCE	15.45 GROUND ELEV. UNDER C.P.
95.01 LOT DEPTH	30 HEIGHT LIMIT
0.0035 SLOPE PER FOOT	45.31 MAX. HEIGHT LIMIT AT C.P.
0.5 DISTANCE SOUTH SIDE TO C.P.	
CRITICAL POINT 08	
NORTH SIDE	SOUTH SIDE
19.33 DISTANCE FROM LOW POINT	19.33 DISTANCE FROM LOW POINT
0.06 RISE ALONG P.L.	0.06 RISE ALONG P.L.
15.59 LOW CORNER	15.25 LOW CORNER
15.64 P.L. ELEV. AT C.P.	15.31 P.L. ELEV. AT C.P.
CROSS LOT	
15.64 NORTH SIDE ELEV. AT C.P.	0.02 TOTAL RISE TO C.P. (GROUND LEVEL)
15.31 SOUTH SIDE ELEV. AT C.P.	15.35 SOUTH SIDE ELEV. AT C.P.
0.3318 DIFFERENCE	15.45 GROUND ELEV. UNDER C.P.
95.01 LOT DEPTH	30 HEIGHT LIMIT
0.0034 SLOPE PER FOOT	45.45 MAX. HEIGHT LIMIT AT C.P.
28.17 DISTANCE SOUTH SIDE TO C.P.	
CRITICAL POINT 09	
NORTH SIDE	SOUTH SIDE
10.83 DISTANCE FROM LOW POINT	10.83 DISTANCE FROM LOW POINT
0.05 RISE ALONG P.L.	0.06 RISE ALONG P.L.
15.59 LOW CORNER	15.25 LOW CORNER
15.62 P.L. ELEV. AT C.P.	15.28 P.L. ELEV. AT C.P.
CROSS LOT	
15.62 NORTH SIDE ELEV. AT C.P.	0.06 TOTAL RISE TO C.P. (GROUND LEVEL)
15.28 SOUTH SIDE ELEV. AT C.P.	15.28 SOUTH SIDE ELEV. AT C.P.
0.3354 DIFFERENCE	15.45 GROUND ELEV. UNDER C.P.
95.01 LOT DEPTH	30 HEIGHT LIMIT
0.0035 SLOPE PER FOOT	45.35 MAX. HEIGHT LIMIT AT C.P.
18.00 DISTANCE SOUTH SIDE TO C.P.	
CRITICAL POINT 10	
NORTH SIDE	SOUTH SIDE
5.00 DISTANCE FROM LOW POINT	5.00 DISTANCE FROM LOW POINT
0.01 RISE ALONG P.L.	0.02 RISE ALONG P.L.
15.59 LOW CORNER	15.26 LOW CORNER
15.60 P.L. ELEV. AT C.P.	15.27 P.L. ELEV. AT C.P.
CROSS LOT	
15.60 NORTH SIDE ELEV. AT C.P.	0.06 TOTAL RISE TO C.P. (GROUND LEVEL)
15.27 SOUTH SIDE ELEV. AT C.P.	15.27 SOUTH SIDE ELEV. AT C.P.
0.3379 DIFFERENCE	15.33 GROUND ELEV. UNDER C.P.
95.01 LOT DEPTH	30 HEIGHT LIMIT
0.0036 SLOPE PER FOOT	45.33 MAX. HEIGHT LIMIT AT C.P.
18.00 DISTANCE SOUTH SIDE TO C.P.	

ROOF LEVEL CRITICAL POINT HEIGHT CALCULATIONS
SCALE: 1/4"=1'-0"

THESE PLANS APPROVED BY PLANNING
DIVISION CITY OF HERMOSA BEACH
DEC 03 2015

FOR PERMIT ISSUANCE
HAYER CONSULTANTS
DEC 03 2015

The issuance or granting of a permit based on approval of these plans SHALL NOT be construed to permit or approve any violation of the applicable code, ordinance, state or federal laws. No permit shall be issued or renewed unless the applicant has provided all the information required by the applicable code, ordinance, state or federal laws.

ENVIROTECHNO
INTERACTIVE ARCHITECTURE +
INTERIOR DESIGN
13101 WASHINGTON BOULEVARD, #404
LOS ANGELES, CALIFORNIA 90066
e-mail: hsa@envirotechno.com
website: envirotechno.com



CLIENT NAME:
**HERMOSA BOUTIQUE
HOTEL, LLC**
RAUL CHABRIA & RAVI KHOSLA
205 PIER AVENUE, SUITE 201
HERMOSA BEACH, CA 90254

PROJECT TITLE:
**HERMOSA
BOUTIQUE HOTEL**
1429 HERMOSA AVENUE
HERMOSA BEACH, CA 90254


SHEET TITLE:
**ROOF LEVEL CRITICAL
POINTS HEIGHT
CALCULATIONS**

JOB NO.: 0012-03
DATE: 09-17-12
SCALE: AS NOTED
DRAWN BY: ENM
CHECKED BY: LDM
SHEET NO.:

REVISION #1 - 08/05/2015
PLAN CHECK RESUBMITTAL - 12/02/15

A6.1

Drawings and specifications are instruments of service and are not to be used for any other purpose. Any use or reproduction of the drawings is made or part by any person who is not a party to the contract is prohibited except as specifically permitted in writing. The drawings are the property of the architect and shall remain the property of the architect. No part of the drawings shall be reproduced or transmitted in any form or by any means, electronic, mechanical, photocopying, recording, or by any information storage and retrieval system, without the prior written permission of the architect. The drawings are the property of the architect and shall remain the property of the architect. No part of the drawings shall be reproduced or transmitted in any form or by any means, electronic, mechanical, photocopying, recording, or by any information storage and retrieval system, without the prior written permission of the architect.

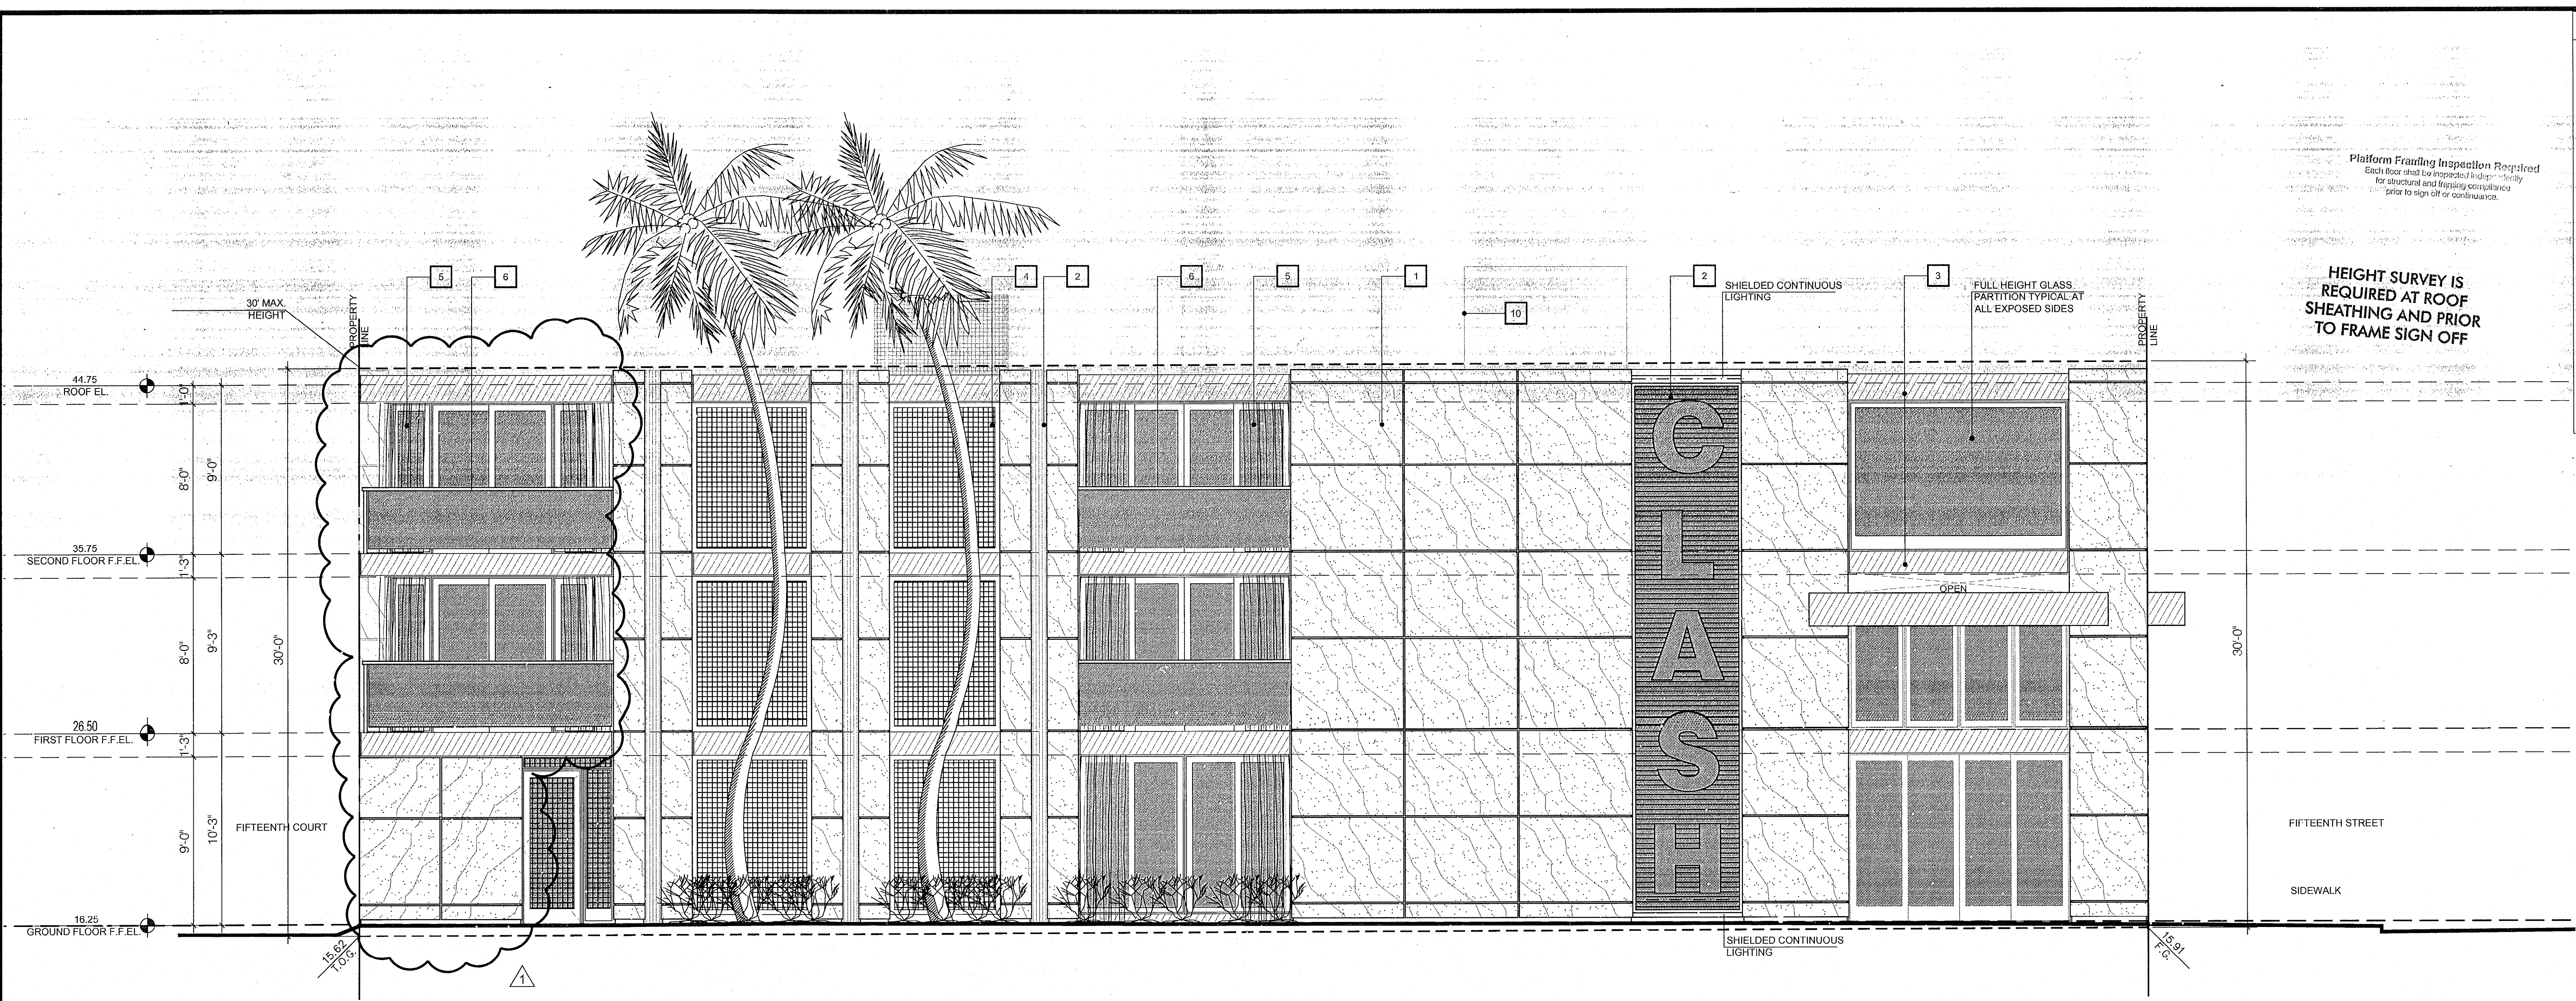

- FINISH SURFACES**
- 1 NON-REFLECTIVE METAL PANEL
 - 2 TEXTURED GLASS PANEL
 - 3 NON-REFLECTIVE METAL FASCIA
 - 4 WIRE-MESH WINDOW BEHIND
 - 5 CURTAINS
 - 6 GLASS RAILING
 - 7 LINE OF TRANSFORMER
 - 8 LINE OF WALL/GATE
 - 9 FILTERED ROOF DRAIN SYSTEM AND STORAGE PIPE AND GIP CHAMBERS - SEE CIVIL SHEETS
 - 10 REQUIRED ELEVATOR OVERHEAD CLEARANCE AND ELEVATOR MACHINE ROOM, STUCCO EXTERIOR FINISH
 - 11 SAFETY BEAM REQUIRED PER OSHA 1926.502, VERIFY WITH ELEVATOR MFG. REQUIREMENTS
 - 12 ELEVATOR PIT - VERIFY REQUIREMENTS PER ELEVATOR SPECIFICATIONS

ENVIROTECHNO
INTERACTIVE ARCHITECTURE + INTERIOR DESIGN
13101 WASHINGTON BOULEVARD, #404
LOS ANGELES, CALIFORNIA 90066
310.377.7873 VOICE
e-mail: kus@envirotechno.com
website: envirotechno.com
08/05/2015

APPROVED ARCHITECT
JULIE MORRIS
ARCHITECT
STATE OF CALIFORNIA
JULIE MORRIS
ARCHITECT
STATE OF CALIFORNIA

CLIENT NAME:
HERMOSA BOUTIQUE HOTEL, LLC
RAUL CHABRIA & RHAVI KHOSLA
205 PIER AVENUE, SUITE 201
HERMOSA BEACH, CA 90254

PROJECT TITLE:
HERMOSA BOUTIQUE HOTEL
1429 HERMOSA AVENUE
HERMOSA BEACH, CA 90254

SHEET TITLE:
SOUTH ELEVATION
EAST ELEVATION

REVISION #1 - 08/05/2015
PLAN CHECK RESUBMITTAL - 12/02/15

JOB NO: 0012-03
DATE: 09-17-12
SCALE: AS NOTED
DRAWN BY: ENM
CHECKED BY: LDM
SHEET NO:

A7.1

TABLE S306.1 - PROTECTION OF PEDESTRIANS

HEIGHT OF CONSTRUCTION	DISTANCE FROM CONSTRUCTION	PROTECTION REQUIRED
Eight feet or less	Less than five feet	Fencing
	Five feet or more	None
	Less than five feet	Fence and canopy
Five feet or more, but not more than 14 feet	Less than five feet	Fence and canopy
	Five feet or more, but between 14 to 17 feet	Fence
Five feet or more, but exceeding 17 feet	Five feet or more, but exceeding 17 feet	None

B EAST ELEVATION
SCALE: 1/4"=1'-0"

SEC. 8.24.060. (a) H.B.M.C.
PERMITTED HOURS OF CONSTRUCTION
8AM TO 6PM MON THUR FRI
9AM TO 5PM SATURDAYS
& NATIONAL HOLIDAYS
VIOLATIONS SUBJECT TO CITATION

THESE PLANS APPROVED BY PLANNING
DIVISION CITY OF HERMOSA BEACH
DEC 03 2015


THESE PLANS APPROVED BY BUILDING
DIVISION CITY OF HERMOSA BEACH
DEC 16 2015

SUBLIST REQUIRED PRIOR TO FINAL
NOTE: ALL WORK SHALL COMPLY
WITH THE 2013 CALIFORNIA BUILDING
CODES AND THE HERMOSA BEACH
MUNICIPAL CODE AS APPLICABLE.

HERMOSA AVENUE
SIDEWALK

RECOMMENDED
FOR PERMIT ISSUANCE
HAVER CONSULTANTS
DEC 9 2015

The issuance or granting of a permit based on approval of these plans SHALL NOT be construed to permit or approve any violation of the applicable codes, ordinance, state or federal laws. No permit presumed to give authority to violate or cancel the provisions of such codes or laws shall be valid.

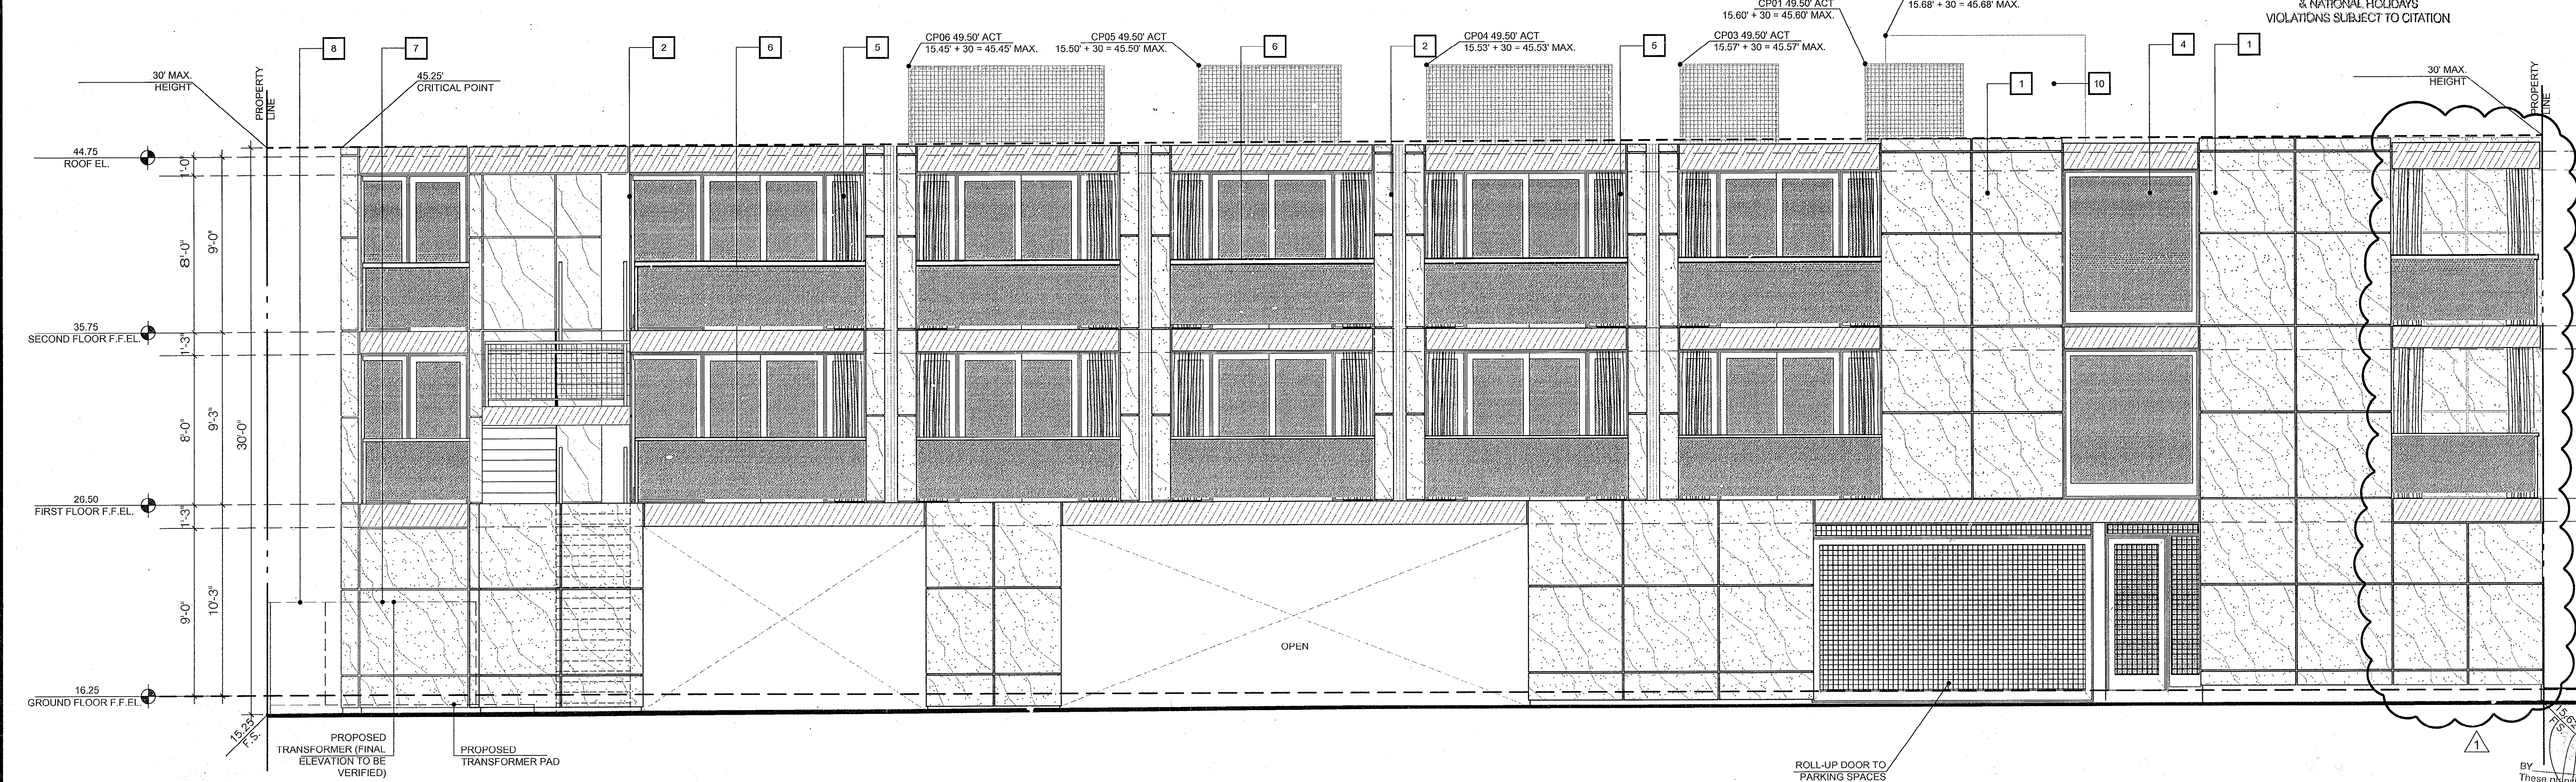

A SOUTH ELEVATION
SCALE: 1/4"=1'-0"

